


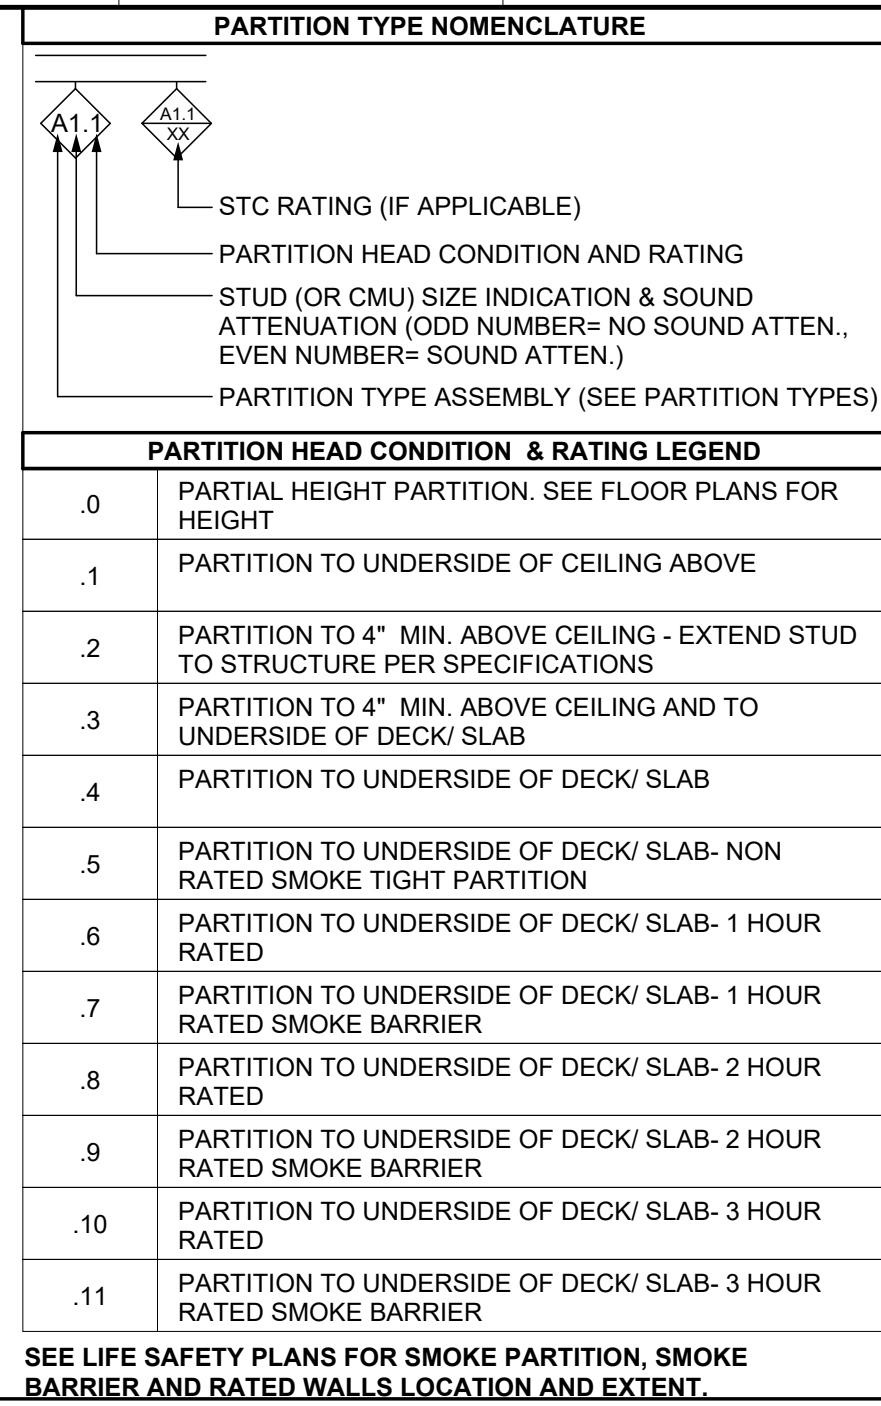

KEYNOTE LEGEND	
051200.A03	W-SHAPE
051200.A01	STEEL JOIST
051200.B01	ROOF DECK
072100.D01	LOOSE-FILL INSULATION
078443.A00	JOINT FIRESTOPPING
092216.A00	NON-STRUCTURAL METAL FRAMING
092216.C01	1-5/8 INCHES (41 MM) METAL STUD
092216.C06	METAL STUD TRACK
092200.B05	5/8" INTERIOR GYPSUM BOARD - TYPE X
092200.C02	CORNERBEAD
092200.C05	EXPANSION (CONTROL) JOINT
092200.D01	ACOUSTICAL SEALANT
134900.E01	LEAD-LINED GYPSUM BOARD





CDH
ARCHITECTURE

3330 Cumberland Blvd. SE
Suite 100
Atlanta, GA 30339
770.423.0016
www.cdhparkers.com

COPYRIGHT © 2025 by CDH PARTNERS INC.

A001	1" = 1'-0"
------	------------



A001	1 1/2" = 1'-0'
------	----------------

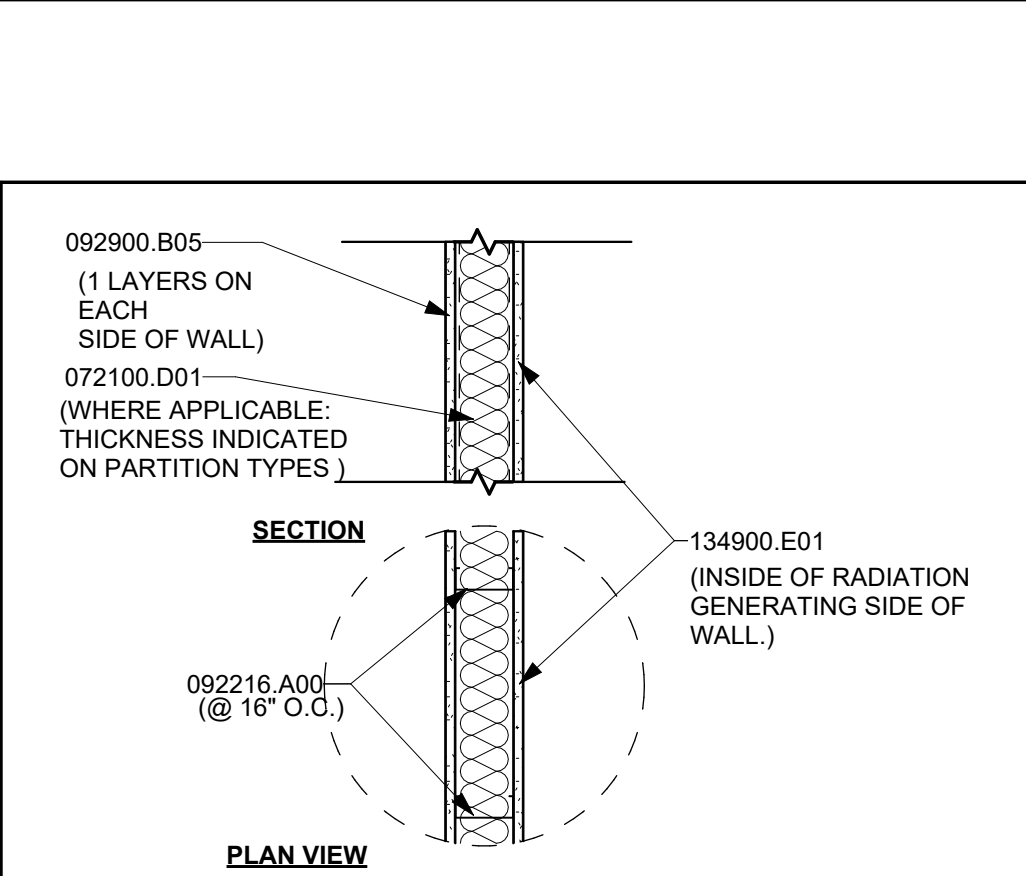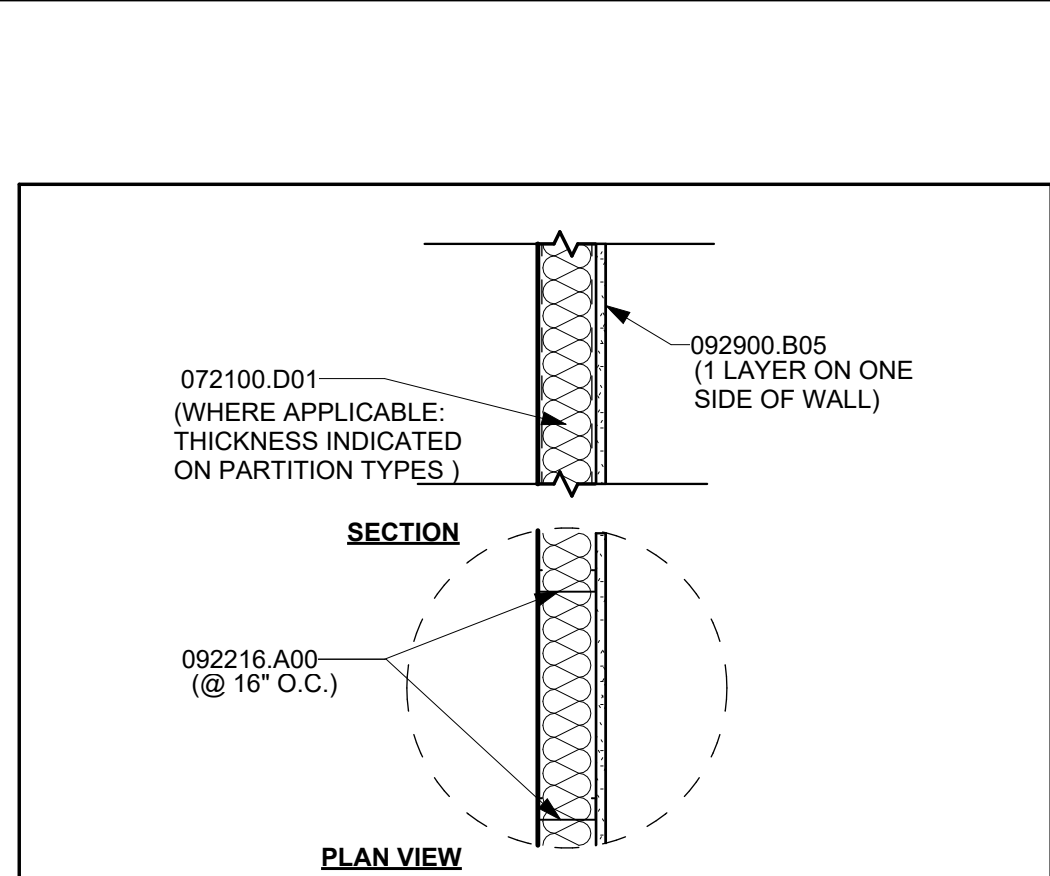


PARTITION TYPE: 'A'							
TYPE MARK	STUD WIDTH	GWB THK	FIRE RATING	UL LISTING (VERIFY)	SOUND BATT	STC RATING (VERIFY)	PART. WIDTH
A5.0	3 5/8"	5/8"	NA	NA	NO SOUND BATT		4 7/8"
A5.4	3 5/8"	5/8"	NA	NA	NO SOUND BATT		4 7/8"
A6.4	3 5/8"	5/8"	NA	NA	SOUND BATT		4 7/8"
A9.0	6"	5/8"	NA	NA	NO SOUND BATT		7 1/4"
A10.4	6"	5/8"	NA	NA	SOUND BATT		7 1/4"

PARTITION TYPE: 'D'							
TYPE MARK	STUD WIDTH	GWB THK	FIRE RATING	UL LISTING (VERIFY)	SOUND BATT	STC RATING (VERIFY)	PART. WIDTH
D1.4	1 5/8"	5/8"	NA	NA	NO SOUND BATT		2 1/4"
D1.4	1 5/8"	5/8"	NA	NA	NO SOUND BATT		2 1/4"
D5.4	3 5/8"	5/8"	NA	NA	NO SOUND BATT		4 1/4"
D1.4	1 5/8"	5/8"	NA	NA	NO SOUND BATT		2 1/4"


PARTITION TYPE: "E" LEAD LINED							
TYPE MARK	STUD WIDTH	GWB THK	FIRE RATING	UL LISTING (VERIFY)	SOUND BATT	STC RATING (VERIFY)	PART. WIDTH
E5.4	3 5/8"	5/8"	NA	NA	NO SOUND BATT		4 7/8"
E6.4	3 5/8"	5/8"	NA	NA	SOUND BATT		4 7/8"

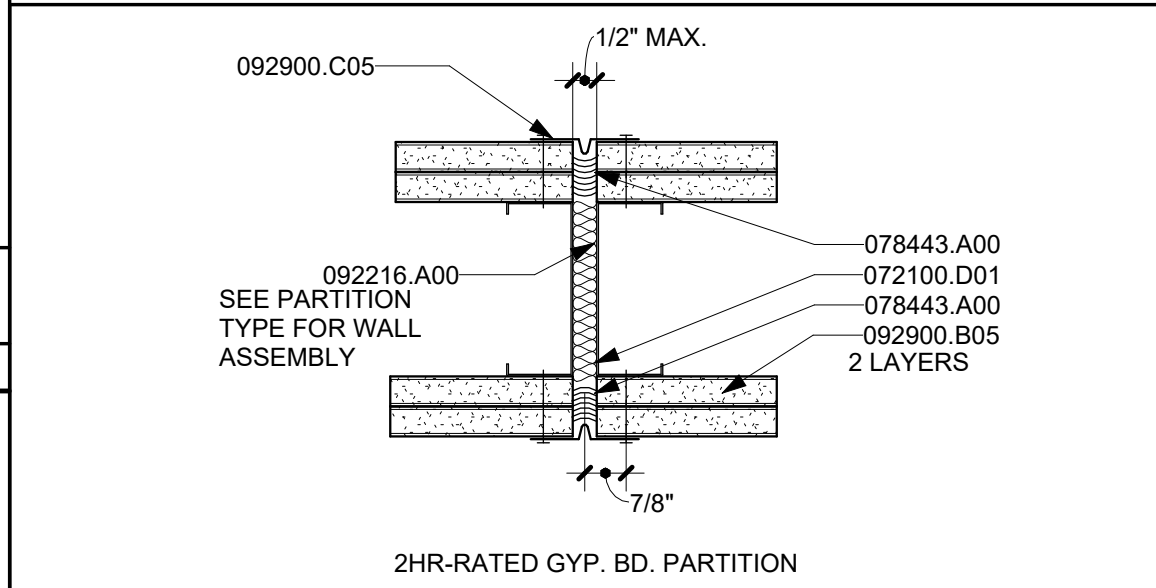 

A001	3" = 1'-0"
------	------------

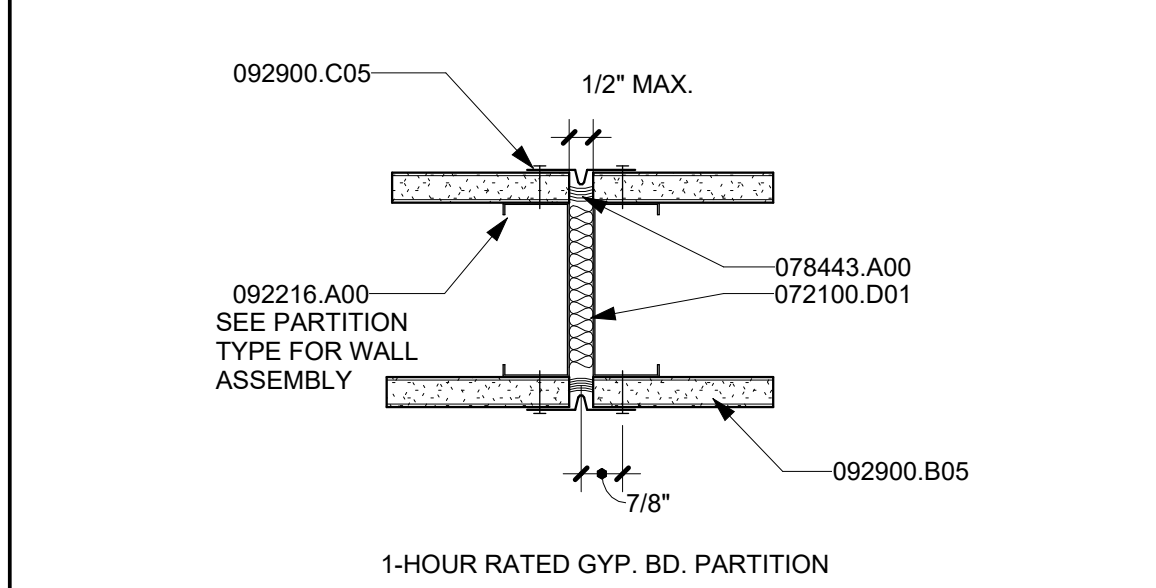

A001	3" = 1'-0"
------	------------

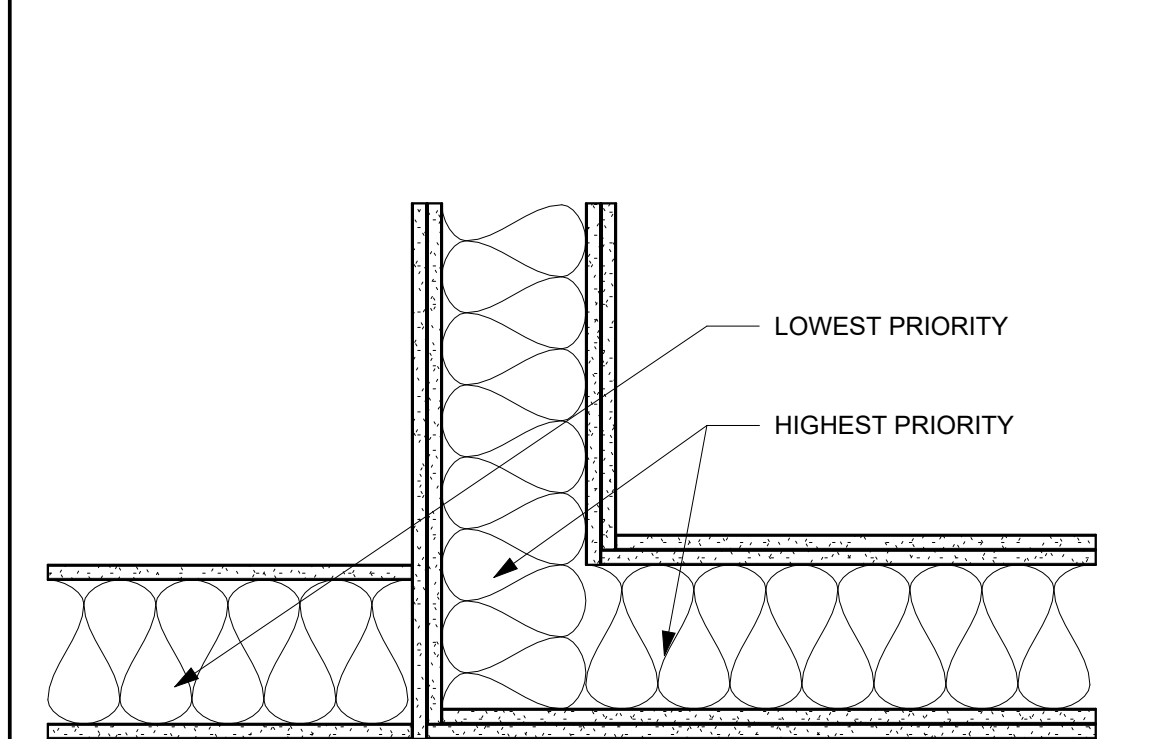

TWO HOUR FIRE & SMOKE WALL.....	PRIORITY 1 HIGHEST
TWO HOUR FIRE WALL.....	PRIORITY 2
TWO HOUR SHAFT WALL.....	PRIORITY 3
ONE HOUR FIRE & SMOKE WALL.....	PRIORITY 3
ONE HOUR FIRE WALL.....	PRIORITY 4
NON-RATED WALL.....	PRIORITY 5 LOWEST

PROVIDE ALL RATED WALLS IN ACCORDANCE WITH UL LISTING.
 MANUFACTURER'S INSTRUCTIONS AND APPROVED HRS DETAILS.
 REFER TO LIFE SAFETY PLANS FOR TYPE, LOCATION AND EXTENT
 OF ALL RATED WALLS.

- | PARTITION NOTES | |
|-----------------|---|
| 1. | <p>THE PARTITION TYPE SYMBOL DESIGNATION CONSISTS OF THREE CHARACTERS. THE FIRST CHARACTER IS A LETTER INDICATING THE PARTITION TYPE ASSEMBLY.</p> <p>THE SECOND CHARACTER IS A NUMBER THAT DESIGNATES THE STUD (OR CMU) SIZE AND IF THE PARTITION HAS SOUND ATTENUATION, AN EVEN NUMBER IS USED WHEN THE PARTITION TYPE DOES NOT HAVE SOUND ATTENUATION, AN EVEN NUMBER IS USED WHEN THE PARTITION TYPE HAS SOUND ATTENUATION.</p> <p>THE THIRD CHARACTER IS A NUMBER THAT INDICATES THE PARTITION TYPE, SOUND ATTENUATION AND RATING (IF APPLICABLE). SEE PARTITION HEAD CONDITION & RATING LEGEND.</p> |
| 2. | SEE FLOOR PLANS FOR LOCATION AND EXTENT. |
| 3. | WHERE DIFFERENT PARTITION TYPES ARE SHOWN IN THE SAME PLANE OFFSET STUDS AND/OR PROVIDE ADDITIONAL STUDS TO THE GYPSUM WALLBOARD TO THE NEAREST CORNER, SO THAT THE PARTITION TYPES ARE FLUSH. |
| 4. | SPACE METAL STUDS AT 16" O.C. SPACE METAL STUDS AT MINIMUM 12" O.C. FOR ALL UPPER CABINETS AND ALL UPPER HUNG EQUIPMENT. |
| 5. | FURRING OF PIPES, CONDUIT AND DUCTWORK (UNLESS NOTED OTHERWISE), SHALL MATCH ADJACENT PARTITION TYPE. |
| 6. | ALL WOOD BLOCKING EXCEPT IN TYPE V (COMBUSTIBLE) CONSTRUCTION, SHALL BE FIRE RADIANT TREATED. |
| 7. | WALLS BEHIND PLUMBING FIXTURES SHALL BE MOLD & MILDEW RESISTANT GYPSUM WALLBOARD. |
| 8. | ALL INTERIOR DOOR FRAMES SHALL BE 4" OR MORE FROM AN INTERIOR CORNER (UNLESS NOTED OTHERWISE). |
| 9. | WHERE TUB AND/OR SHOWER ENCLOSURE OCCURS AT A FIRE RATED OR SOUND RATED PARTITION, INSTALL A SECTION OF GYPSUM WALLBOARD PRESCRIBED BY THE PARTITION TYPES PRIOR TO THE INSTALLATION OF THE TUB/SHOWER ENCLOSURE. PROVIDE ADDITIONAL LAYERS OF GYPSUM WALLBOARD AS REQUIRED TO CONCEAL FIXTURE FOLDINGS. |
| 10. | REFERENCE FINISH PLANS FOR BASE MOLDING LOCATION AND TYPE. ALL PARTITIONS RECEIVE BASE MOLDING UNLESS NOTED OTHERWISE. |
| 11. | RYEWALL PARTITIONS INDICATED TO EXTEND TO STRUCTURE SHALL INCLUDE FINISH BEAMS, HEADERS, JOISTS AND/OR DECKS. |
| 12. | CORRIDOR PARTITIONS, SMOKE STOP PARTITIONS, HORIZONTAL EXIT PARTITIONS, EXIT ENCLOSURES AND OTHER FIRE RATED PARTITIONS SHALL BE IDENTIFIED AND IDENTIFIED WITH STENCILING IN A MANNER ACCEPTABLE TO THE AUTHORITY HAVING JURISDICTION. SUCH IDENTIFICATION SHALL BE ABOVE ANY DECORATIVE CEILING OR IN CONCEALED SPACES. SUGGESTED WORDING - "FIRE AND SMOKE BARRIER - PROTECT ALL OPENINGS." |
| 13. | AT PARTITIONS WITH SPECIFIED STC RATINGS, STAGGER AND SEAL ALL WALL BOARD JOINTS, ELECTRIC OUTLETS AND SWITCHES ON OPPOSITE SIDES OF THE PARTITION. ALL PENETRATIONS BY A MINIMUM OF ONE STUD. ALL PENETRATIONS SHALL BE SEALED WITH ACOUSTICAL SEALANT. |
| 14. | PROVIDE RESILIENT CHANNEL ON NOISE GENERATING SIDE OF WALL. |
| 15. | SEE SPECIFICATIONS FOR UNDERLAYMENT REQUIREMENTS AT PARTITION JOINTS THAT RECEIVE WALL TILE OR SPECIAL FINISHES. |

PROJECT NO:		25132.00
DD	DD PACKAGE	12/18/25

NOT ISSUED FOR
CONSTRUCTION

SHEET TITLE

PARTITION
TYPES

SHEET NUMBER

A001

CDH
ARCHITECTURE

3330 Cumberland Blvd. SE
Suite 100
Atlanta, GA 30339
770.423.0016
www.cdpartners.com

COPYRIGHT © 2012 by CDH PARTNERS, INC.
All rights reserved.

GRADY HEALTH SYSTEM

GRADY ESTORIA URGENT CARE

Corner of Memorial Drive & Estoria Street
Atlanta GA 30316

GRADY HEALTH SYSTEM

SYSTEM
URGENT CARE


Estoria Street
16

SHEET TITLE

PARTITION
TYPES


SHEET NUMBER

A001

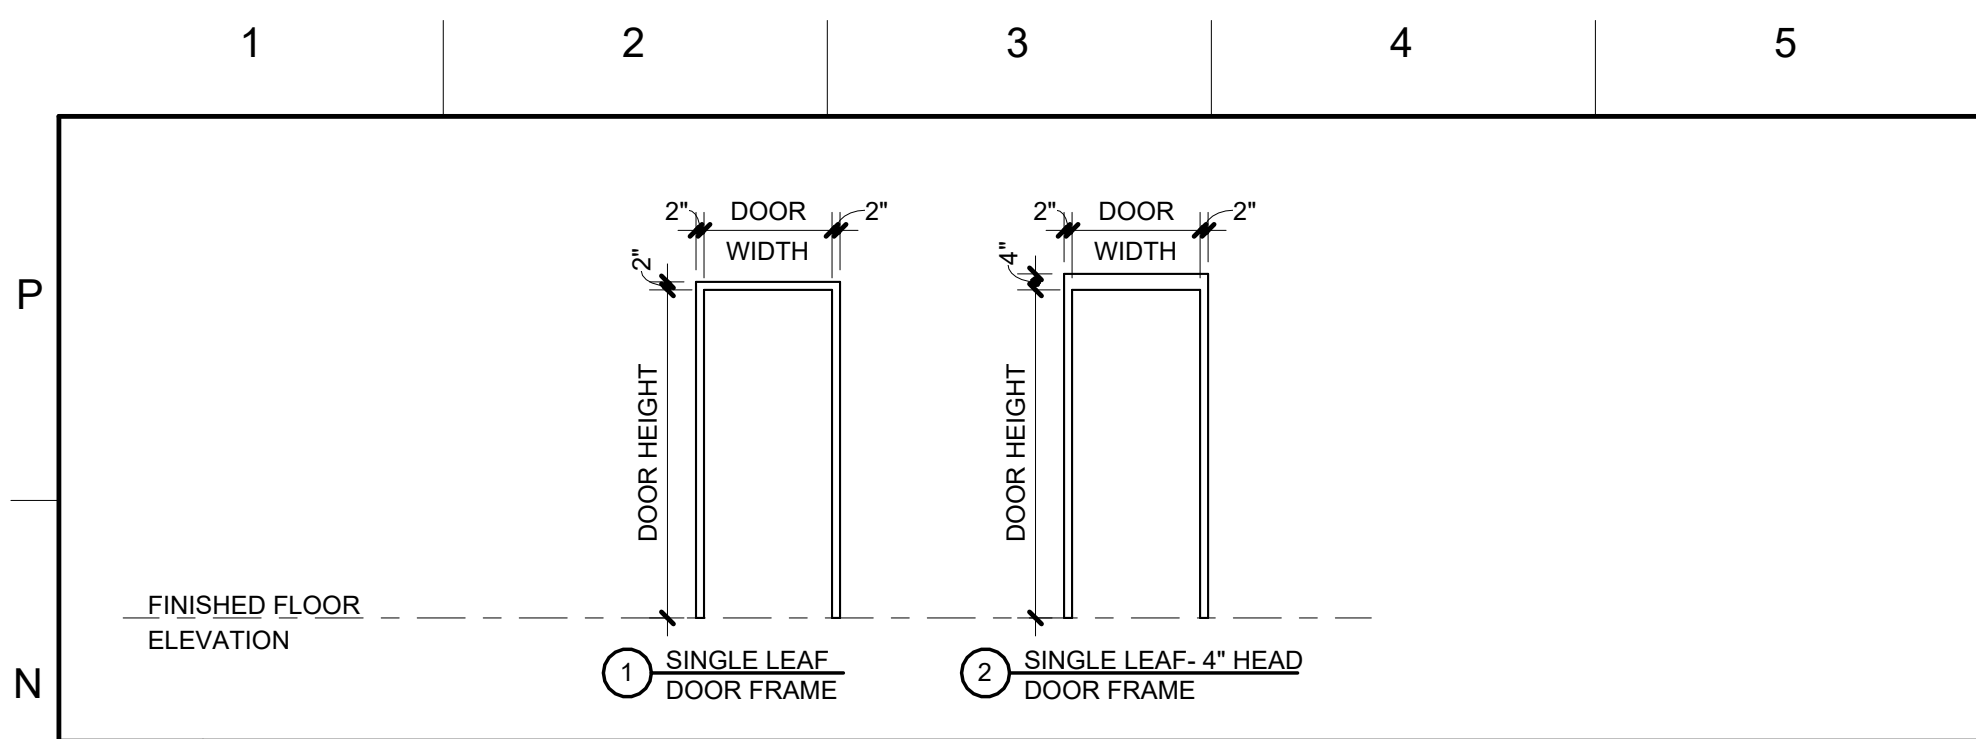


N1 | DOOR FRAME TYPES

A021	1/4" = 1'-0"
------	--------------

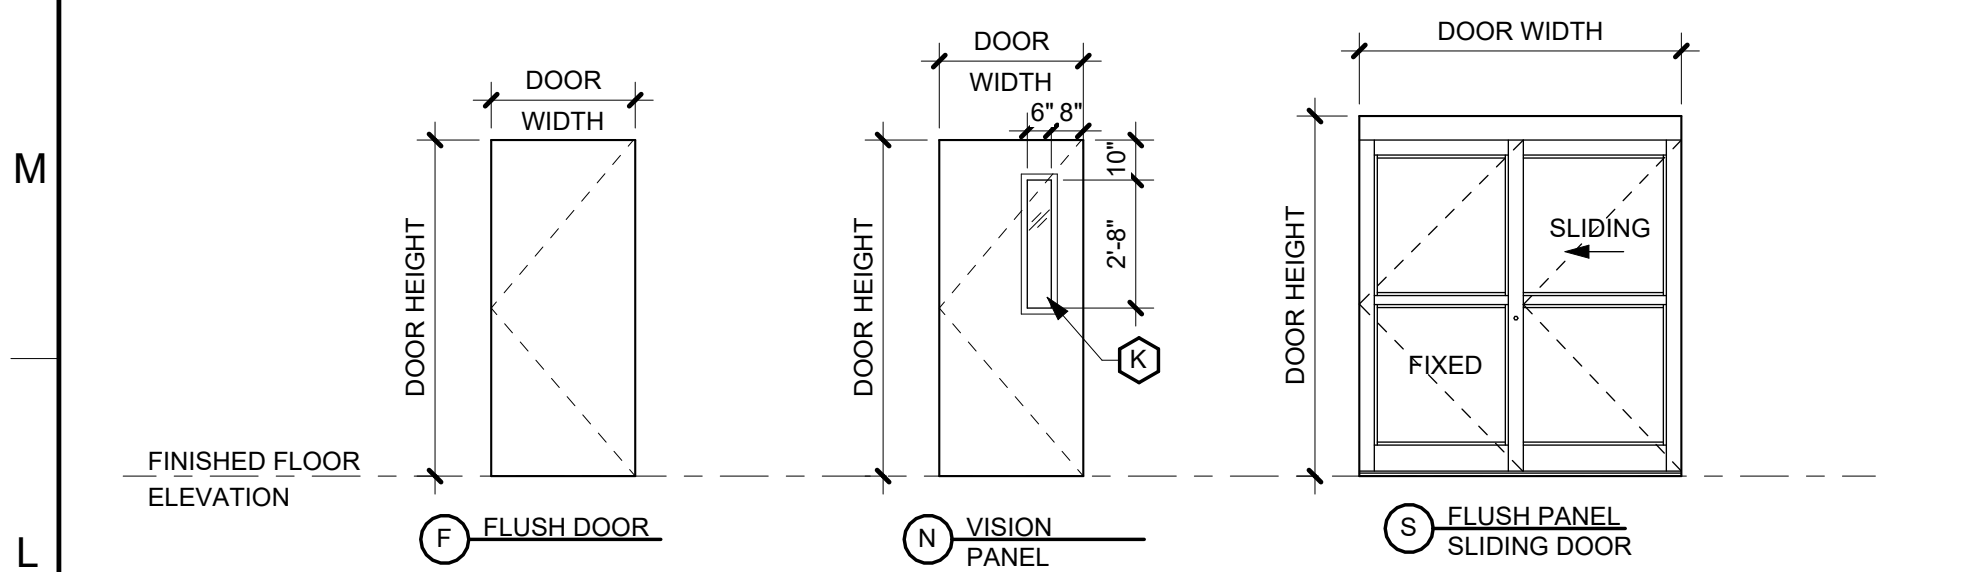

L1 | DOOR ELEVATION TYPES

A021	1/4" = 1'-0"
------	--------------

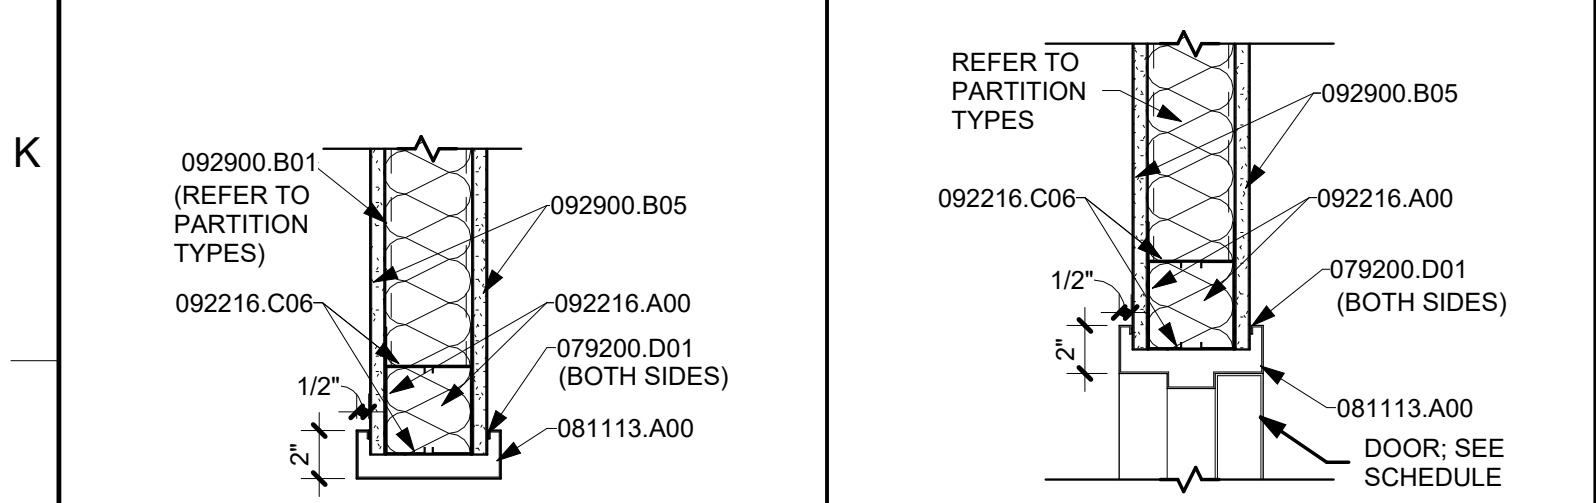


J1	HM C.O.
----	---------

A021	$1\frac{1}{2}'' = 1'-0''$
------	---------------------------

J3 | HM TYP.

A021	1 1/2" = 1'-0"
------	----------------

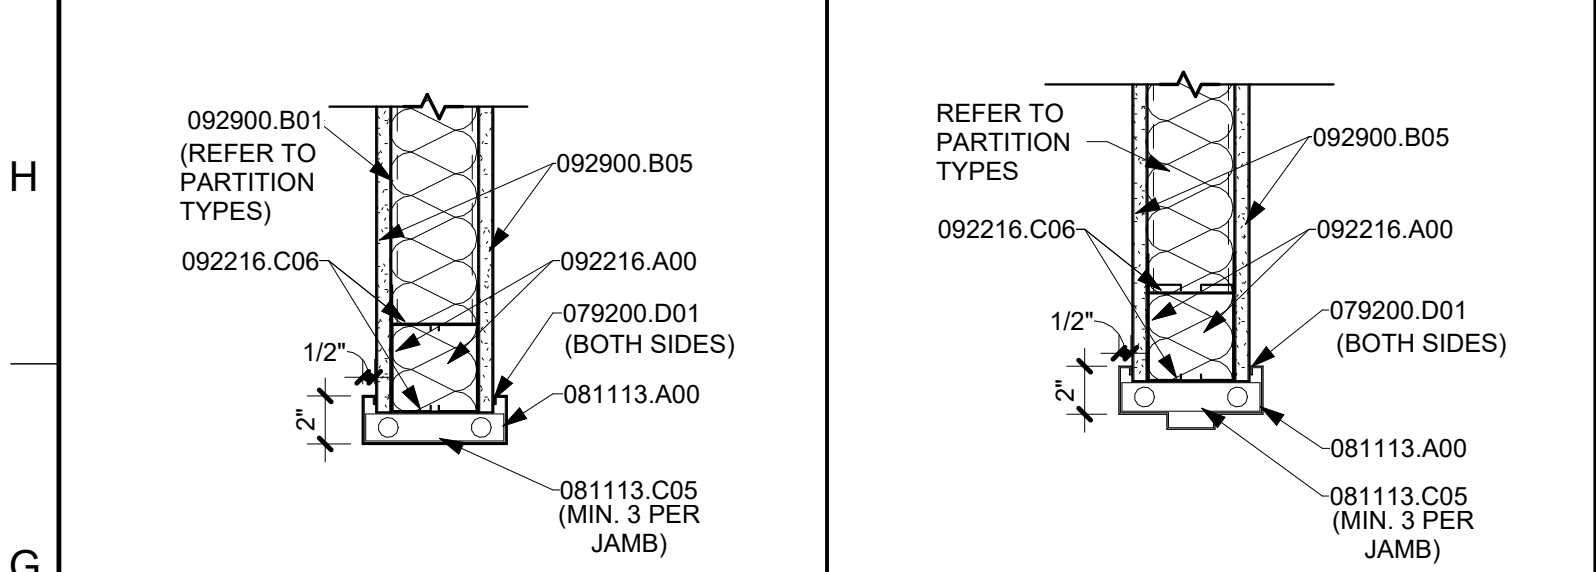


G1	HM C.O.
----	---------

A021	$1\frac{1}{2}'' = 1'-0''$
------	---------------------------

G3	HM TYP
1	1
2	2
3	3
100	100

A021	1 1/2" = 1'-0"
------	----------------

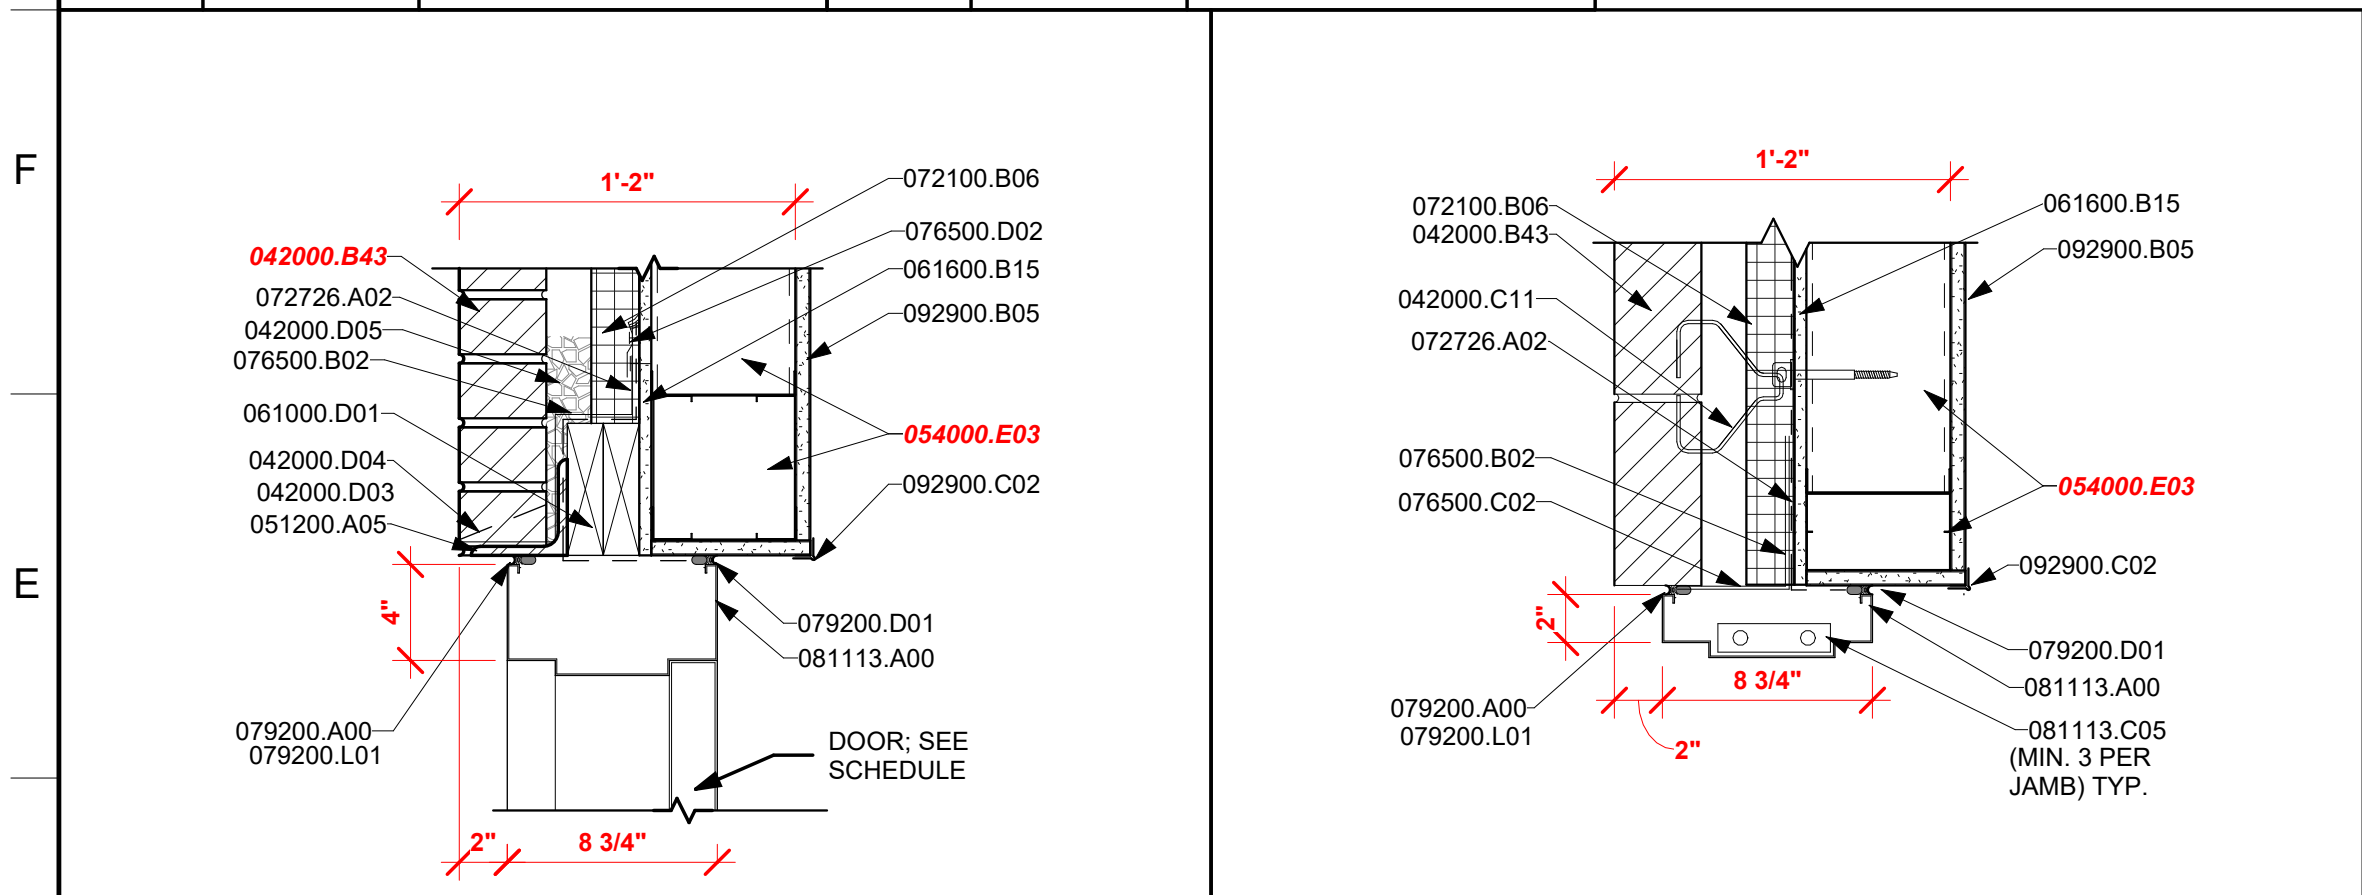

D1	HM- BRICK
----	-----------

A021	$1\frac{1}{2}'' = 1'-0''$
------	---------------------------

D4 | HM-BRICK

A021	$1\frac{1}{2}'' = 1'-0''$
------	---------------------------

DOOR & FRAME SCHEDULE																		
NO.	NAME	TYPE	DOOR			MAT'L	FINISH	LABEL	TYPE	FRAME				HARDWARE		REMARKS	CR PULL	CR PUSH
			WIDTH	HEIGHT	THICK					MAT'L	FINISH	HEAD	JAMB	SILL	FUNCTION			
100.2	VESTIBULE	S	7'-0"	8'-0"	0"	BY MANUF.	BY MANIF.	-	-	BY MANUF.	BY MANUF.					No	No	
101	VESTIBULE	S	7'-0"	8'-0"	0"	BY MANUF.	BY MANIF.	-	-	BY MANUF.	BY MANUF.					No	No	
101.1	CORRIDOR	F	3'-0"	7'-0"	1 3/4"	SCWD	STAIN	-	1	HM	PAINT	J3/A021	G3/A021			Yes	No	
101.2	CORRIDOR	F	3'-0"	7'-0"	1 3/4"	SCWD	STAIN	-	1	HM	PAINT	J3/A021	G3/A021			No	Yes	
101A	TLT	F	3'-0"	7'-0"	1 3/4"	SCWD	STAIN	-	1	HM	PAINT	J3/A021	G3/A021			No	No	
103	CHECK-OUT	F	3'-0"	7'-0"	1 3/4"	SCWD	STAIN	-	1	HM	PAINT	J3/A021	G3/A021			No	No	
103A	CHECK-OUT	-	4'-0"	7'-0"		-	-	-	1	HM	PAINT	J1/A021	G1/A021			No	No	
104	EXAM 1	F	3'-0"	7'-0"	1 3/4"	SCWD	STAIN	-	1	HM	PAINT	J3/A021	G3/A021			No	No	
106	EXAM 2	F	3'-0"	7'-0"	1 3/4"	SCWD	STAIN	-	1	HM	PAINT	J3/A021	G3/A021			No	No	
107	BLOOD / PHLEB WK	F	3'-0"	7'-0"	1 3/4"	SCWD	STAIN	-	1	HM	PAINT	J3/A021	G3/A021			No	No	
108	EXAM 3	F	3'-0"	7'-0"	1 3/4"	SCWD	STAIN	-	1	HM	PAINT	J3/A021	G3/A021			No	No	
109A	MEDICATIONS	N	3'-0"	7'-0"	1 3/4"	SCWD	STAIN	-	1	HM	PAINT	J3/A021	G3/A021			No	No	
110	EXAM 4	F	3'-0"	7'-0"	1 3/4"	SCWD	STAIN	-	1	HM	PAINT	J3/A021	G3/A021			No	No	
111	STAFF TLT.	F	3'-0"	7'-0"	1 3/4"	SCWD	STAIN	-	1	HM	PAINT	J3/A021	G3/A021			No	No	
112	OFFICE	F	3'-0"	7'-0"	1 3/4"	SCWD	STAIN	-	1	HM	PAINT	J3/A021	G3/A021			No	No	
114	OFFICE	F	3'-0"	7'-0"	1 3/4"	SCWD	STAIN	-	1	HM	PAINT	J3/A021	G3/A021			No	No	
116	LOUNGE	F	3'-0"	7'-0"	1 3/4"	SCWD	STAIN	-	1	HM	PAINT	J3/A021	G3/A021			No	Yes	
116A	LOUNGE	F	2'-6"	7'-0"	1 3/4"	SCWD	STAIN	-	1	HM	PAINT	J3/A021	G3/A021			No	No	
119	STAFF TLT.	F	3'-0"	7'-0"	1 3/4"	SCWD	STAIN	-	1	HM	PAINT	J3/A021	G3/A021			No	No	
120	CORRIDOR	F	3'-0"	7'-0"	1 3/4"	SCWD	STAIN	-	1	HM	PAINT	J3/A021	G3/A021			No	No	
122	CORRIDOR	F	3'-6"	7'-0"	1 3/4"	SCWD	STAIN	-	1	HM	PAINT	J3/A021	G3/A021			No	No	
124	ELECTRIC	F	3'-6"	7'-0"	1 3/4"	SCWD	STAIN	-	1	HM	PAINT	J3/A021	G3/A021			No	No	
126	WATER	F	3'-6"	7'-0"	1 3/4"	SCWD	STAIN	-	1	HM	PAINT	J3/A021	G3/A021			No	No	
128	F	F	3'-0"	7'-0"	1 3/4"	SCWD	STAIN	-	1	HM	PAINT	J3/A021	G3/A021			No	No	
130	SOILED	F	3'-0"	7'-0"	1 3/4"	SCWD	STAIN	-	1	HM	PAINT	J3/A021	G3/A021			No	No	
132	EQUIPMENT	F	3'-0"	7'-0"	1 3/4"	SCWD	STAIN	-	1	HM	PAINT	J3/A021	G3/A021			No	No	
133	X-RAY	G	4'-0"	7'-0"	1 3/4"	HM	PAINT	-	1	HM	PAINT					No	Yes	
133A	DRESSING	F	3'-0"	7'-0"	1 3/4"	SCWD	STAIN	-	1	HM	PAINT	J3/A021	G3/A021			No	No	
134	CLEAN	F	3'-0"	7'-0"	1 3/4"	SCWD	STAIN	-	1	HM	PAINT	J3/A021	G3/A021			No	No	
136	OFFICE	F	3'-0"	7'-0"	1 3/4"	SCWD	STAIN	-	1	HM	PAINT	J3/A021	G3/A021			No	No	
138	TREATMENT	F	4'-0"	7'-0"	1 3/4"	SCWD	STAIN	-	1	HM	PAINT					No	No	
139	SPEC TLT.	F	3'-0"	6'-8"	2"	SCWD	STAIN	-	1	HM	PAINT					No	No	
140	EXAM 5	F	3'-0"	7'-0"	1 3/4"	SCWD	STAIN	-	1	HM	PAINT	J3/A021	G3/A021			No	No	
142	EXAM 6	F	3'-0"	7'-0"	1 3/4"	SCWD	STAIN	-	1	HM	PAINT	J3/A021	G3/A021			No	No	
143	PATIENT TOILET	F	3'-0"	6'-8"	2"	SCWD	STAIN	-	1	HM	PAINT					No	No	
903.1	CORRIDOR	F	4'-0"	7'-0"	1 3/4"	HM	PAINT	-	2	HM	PAINT	D1/A021	D4/A021			Yes	No	

KEYNOTE LEGEND

042000.B13	BRICK
042000.C11	ADJUSTABLE MASONRY-VENEER ANCHOR
042000.D03	BRICK WEEP
042000.D04	BRICK WEEP WICK
042000.D05	STONE BED MORTAR STOP CNTNUOUS ANGLE
951200.A05	FRAMING
064000.E03	WOOD-ON-LOAD-BEARING WALL
061000.D01	WOOD-PRESERVATIVE-TREATED 1/2" GLASS-MAT GYPSUM WALL SHEATHING
072000.B06	
072728.A02	HIGH-BUILD, VAPOR-PERMEABLE AIR BARRIER
076500.B02	RUBBERIZED ASPHALT
076500.C02	STAINLESS STEEL
076500.D02	ALUMINUM TERMINATION BAR
079200.A01	JOINT SEALANTS
079200.D01	URETHANE JOINT SEALANT
079200.L01	JOINT SEALANT BACKING
081113.A00	HOLLOW METAL DOORS AND FRAMES
081113.C05	FRAME ANCHOR
092216.A00	NON-STRUCTURAL METAL FRAMING
092216.C06	METAL STUD TRACK
092900.B01	INTERIOR GYPSUM BOARD
092900.C05	5/8" INTERIOR GYPSUM BOARD - TYPE X CORNERBEAD
092900.C02	

GLAZING SCHEDULE	
B	1" INSULATED (CLEAR or TINTED) TEMPERED GLASS
D	1" INSULATED TEMPERED SPANDREL GLASS
E	1/4" CLEAR GLASS
L	LEADED GLASS

NOTES:

1. ALL GLAZING WITHIN 24", MEASURED HORIZONTALLY OF A DOOR, AND ALL GLAZING WITHIN 60" ABOVE THE FINISHED FLOOR SHALL BE 1" TEMPERED GLASS.
2. GLAZING IN ALL DOOR SHALL BE TEMPERED GLASS.

HARDWARE FUNCTION LEGEND			
PA	PASSAGE LATCH SET	DB	DEAD BOLT
PR	PRIVACY LOCK SET	P/P	PUSH/PULL
OL	OFFICE LOCK SET	CL	CLASSROOM LOCK SET
KEY	KEY PAD LOCK	EXIT	EXIT HARDWARE SET
SL	STORAGE LOCK SET	BI-FD	BI-FOLD HARDWARE SET
CLD	CLASSROOM LOCK W/ DUTCH DOOR		


GENERAL NOTESDOOR AND SCHEDULE NOTES

1. INSTALL WEATHER STRIPPING AROUND DOORS.
2. PROVIDE HOLD OPEN DEVICE IN CLOSER.
3. ELECTRONIC ACCESS CONTROL.
4. CAGED OPENING.
5. UNDERCUT DOOR UNIT 3/4".
6. INSTALL SOUND PROOF STRIPPING AROUND DOOR AND PROVIDE AUTOMATIC DOOR BOTTOM.
7. PROVIDE MAGNETIC DOOR HOLDER CONNECTED TO FIRE ALARM FOR DEACTIVATION.
8. EXIT ONLY DOOR. PROVIDE BLANK PLATE ON EXTERIOR.



GRADY HEALTH SYSTEM
GRADY ESTORIA URGENT CARE

PROJECT NO:		25132.00
DD	DD PACKAGE	12/18/25

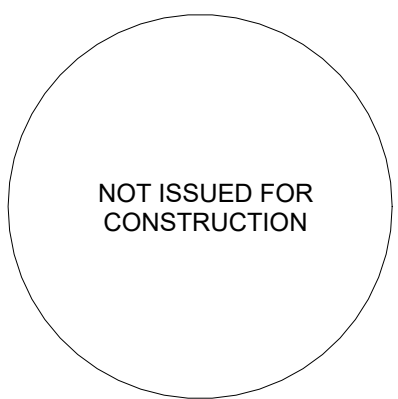[illegible]

DOOR TYPES -
LIBRARY

SHEET NUMBER

A021

12/18/2025 3:18:21 PM



A1 LEVEL 100 FLOOR PLAN

A100 3/16" = 1'-0" 1/ A031

CDH

ARCHITECTURE

3330 Cumberland Blvd. SE
Suite 100
Atlanta, GA 30339
770.423.0016
www.cdhparkers.com

COPYRIGHT © 2025 by CDH PARTNERS INC.
All rights reserved.

GRADY HEALTH SYSTEM

GRADY ESTORIA URGENT CARE

Corner of Memorial Drive & Estoria Street
Atlanta GA 30316

PROJECT NO: 25132.00

DD PACKAGE 12/18/25

NOT ISSUED FOR CONSTRUCTION

KEY PLAN


N

SHEET TITLE


FLOOR PLANS


SHEET NUMBER


A100

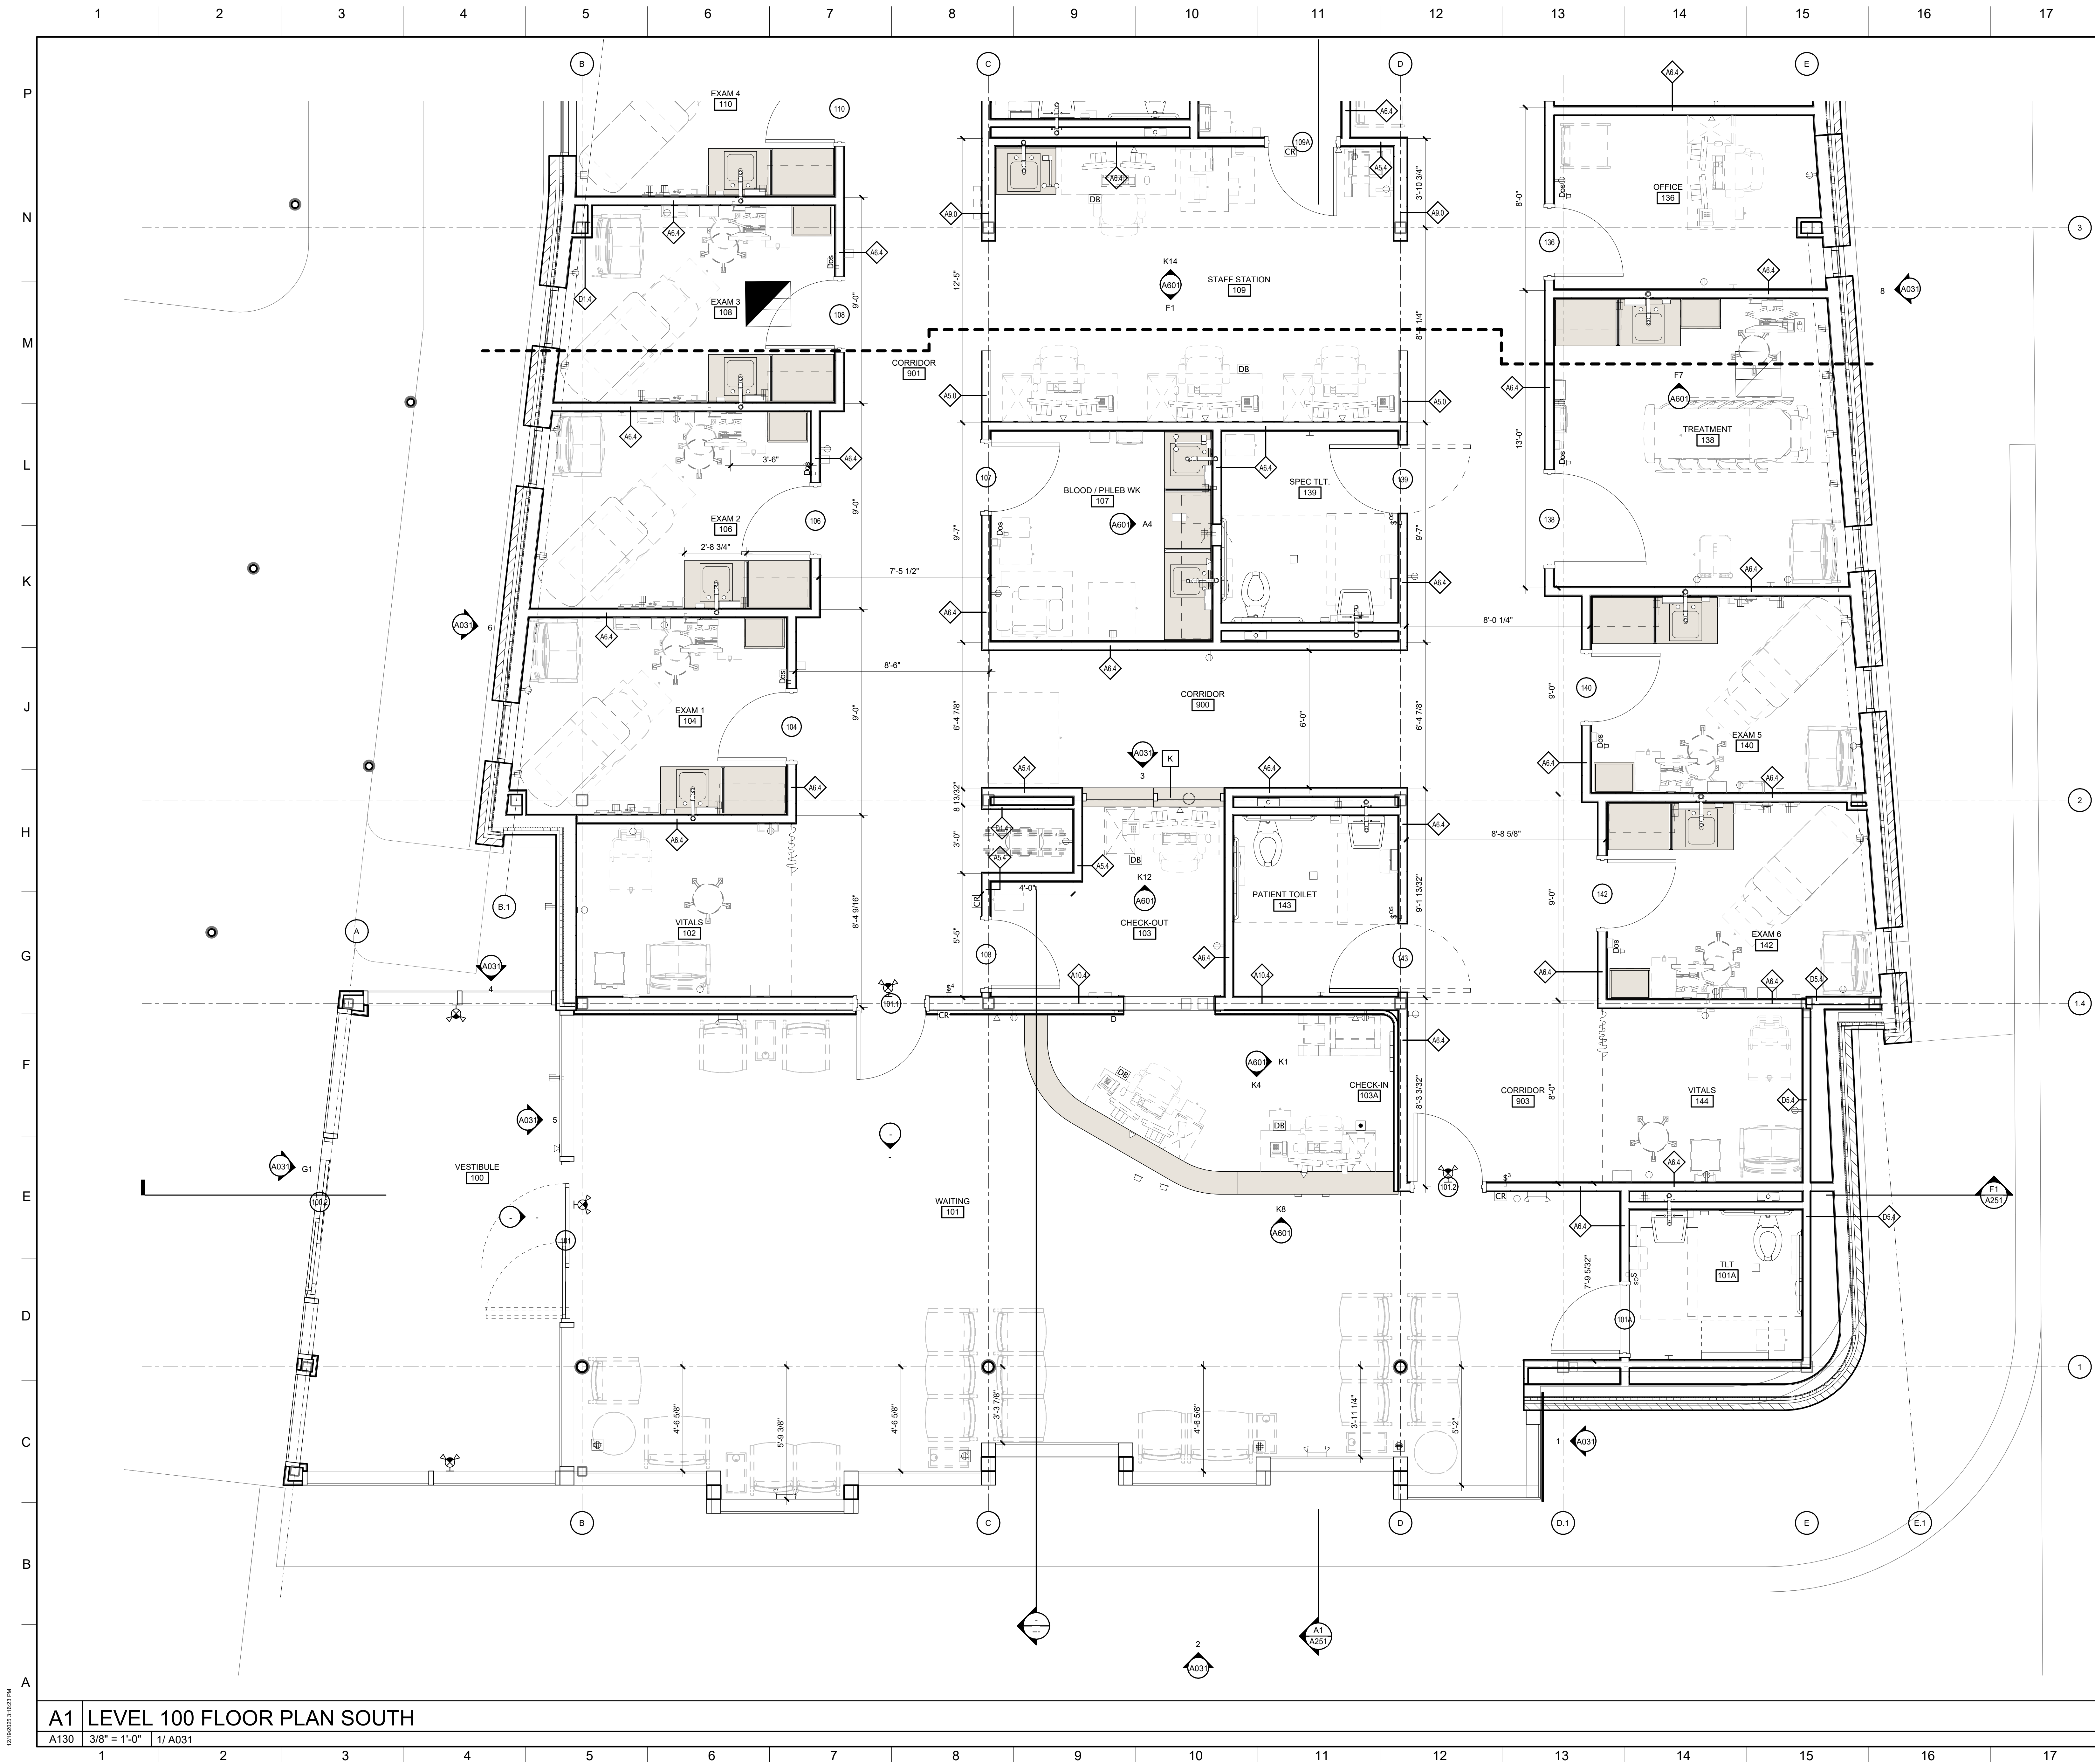

A131

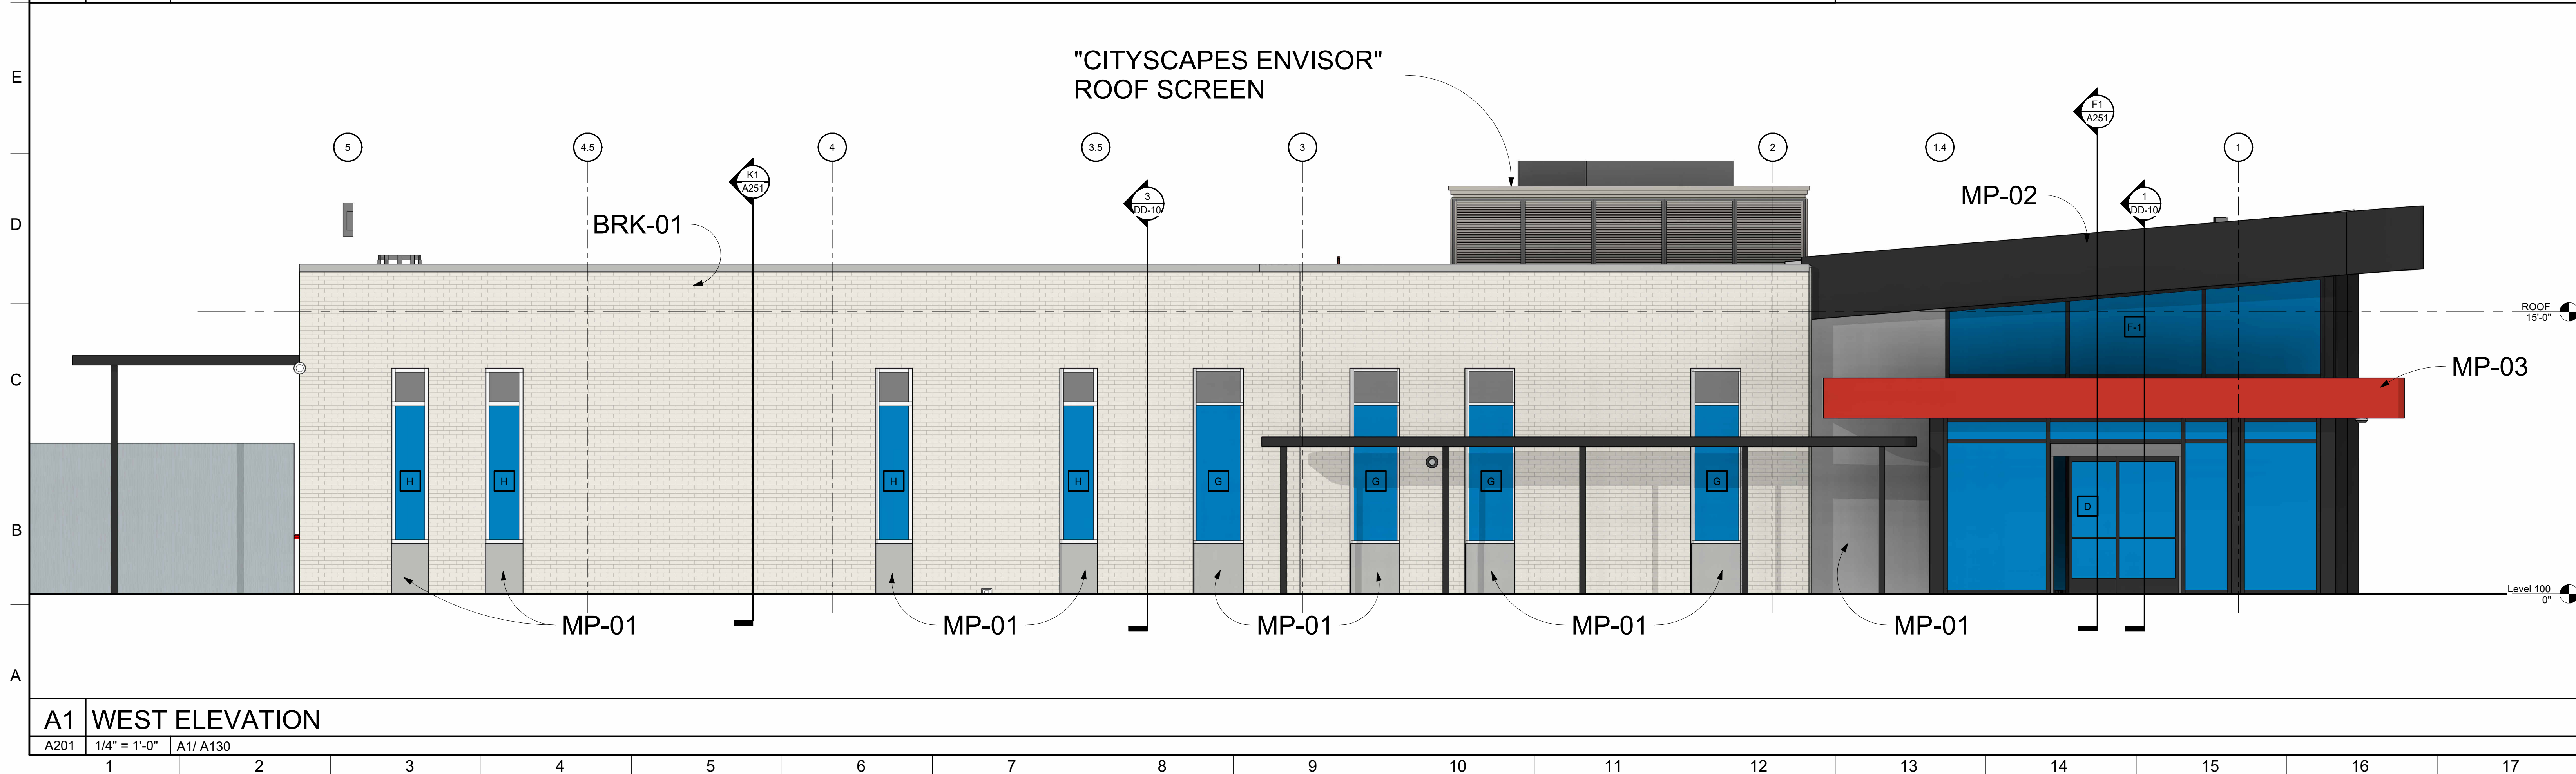[illegible]

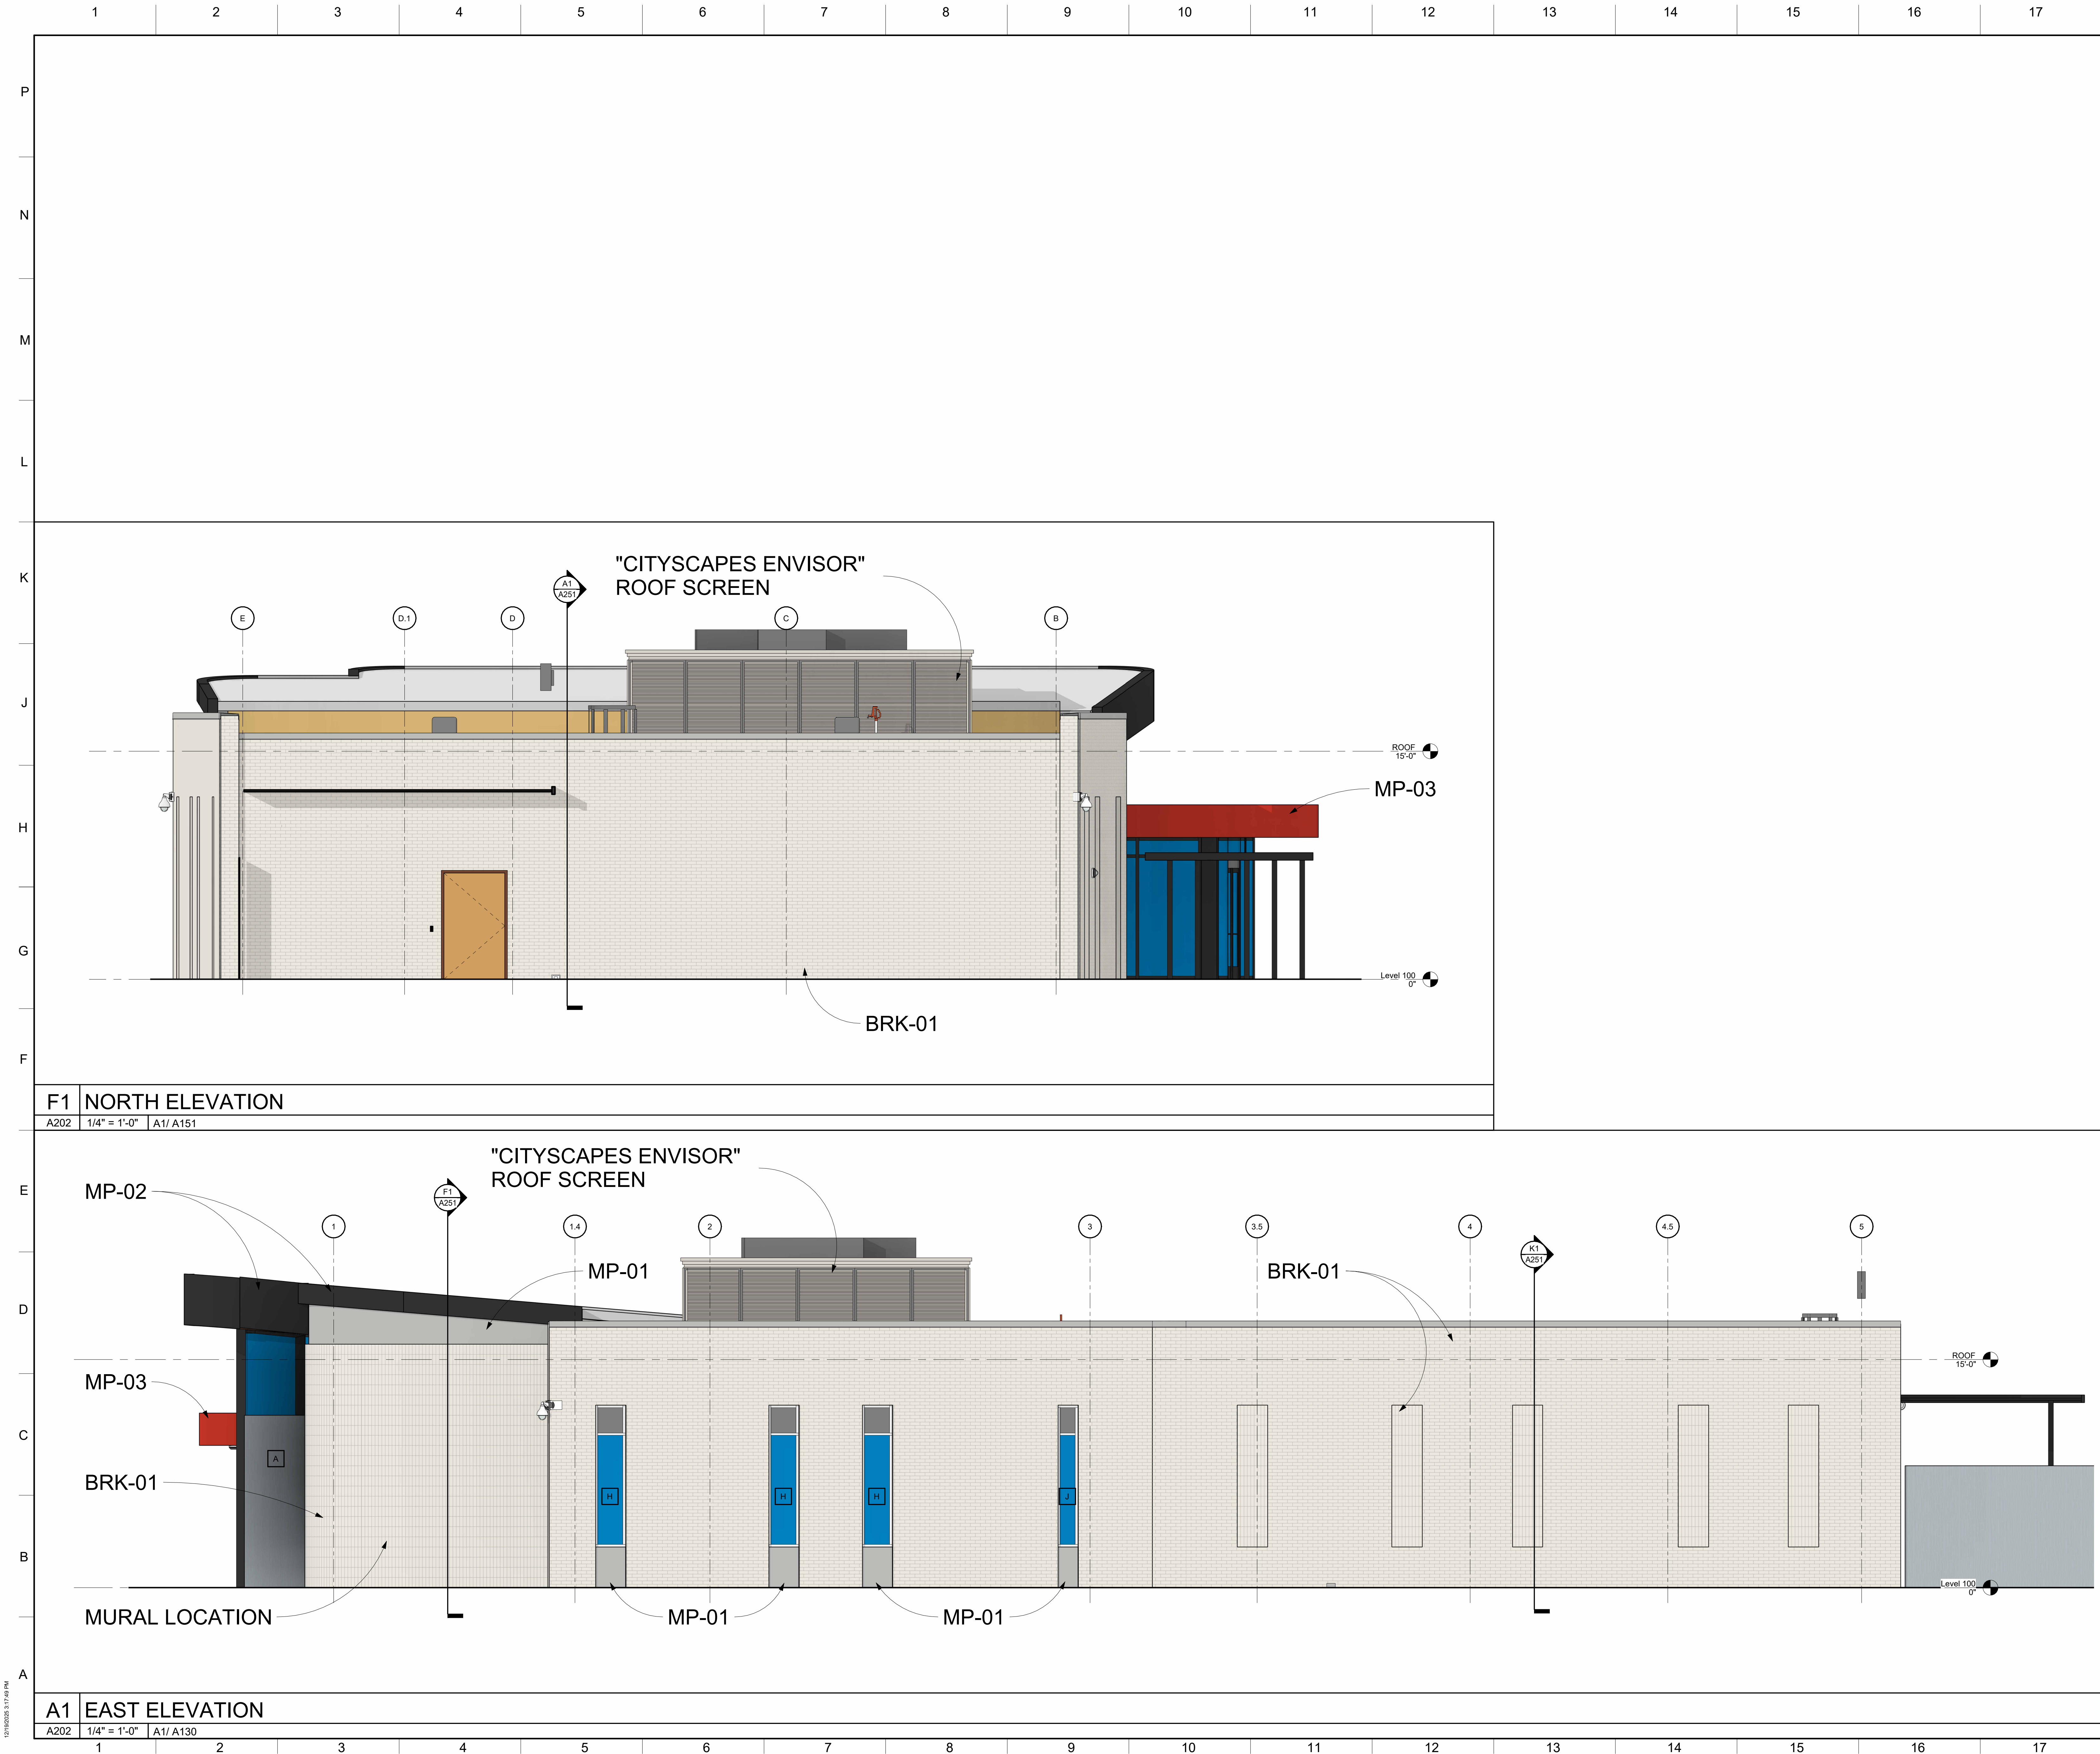

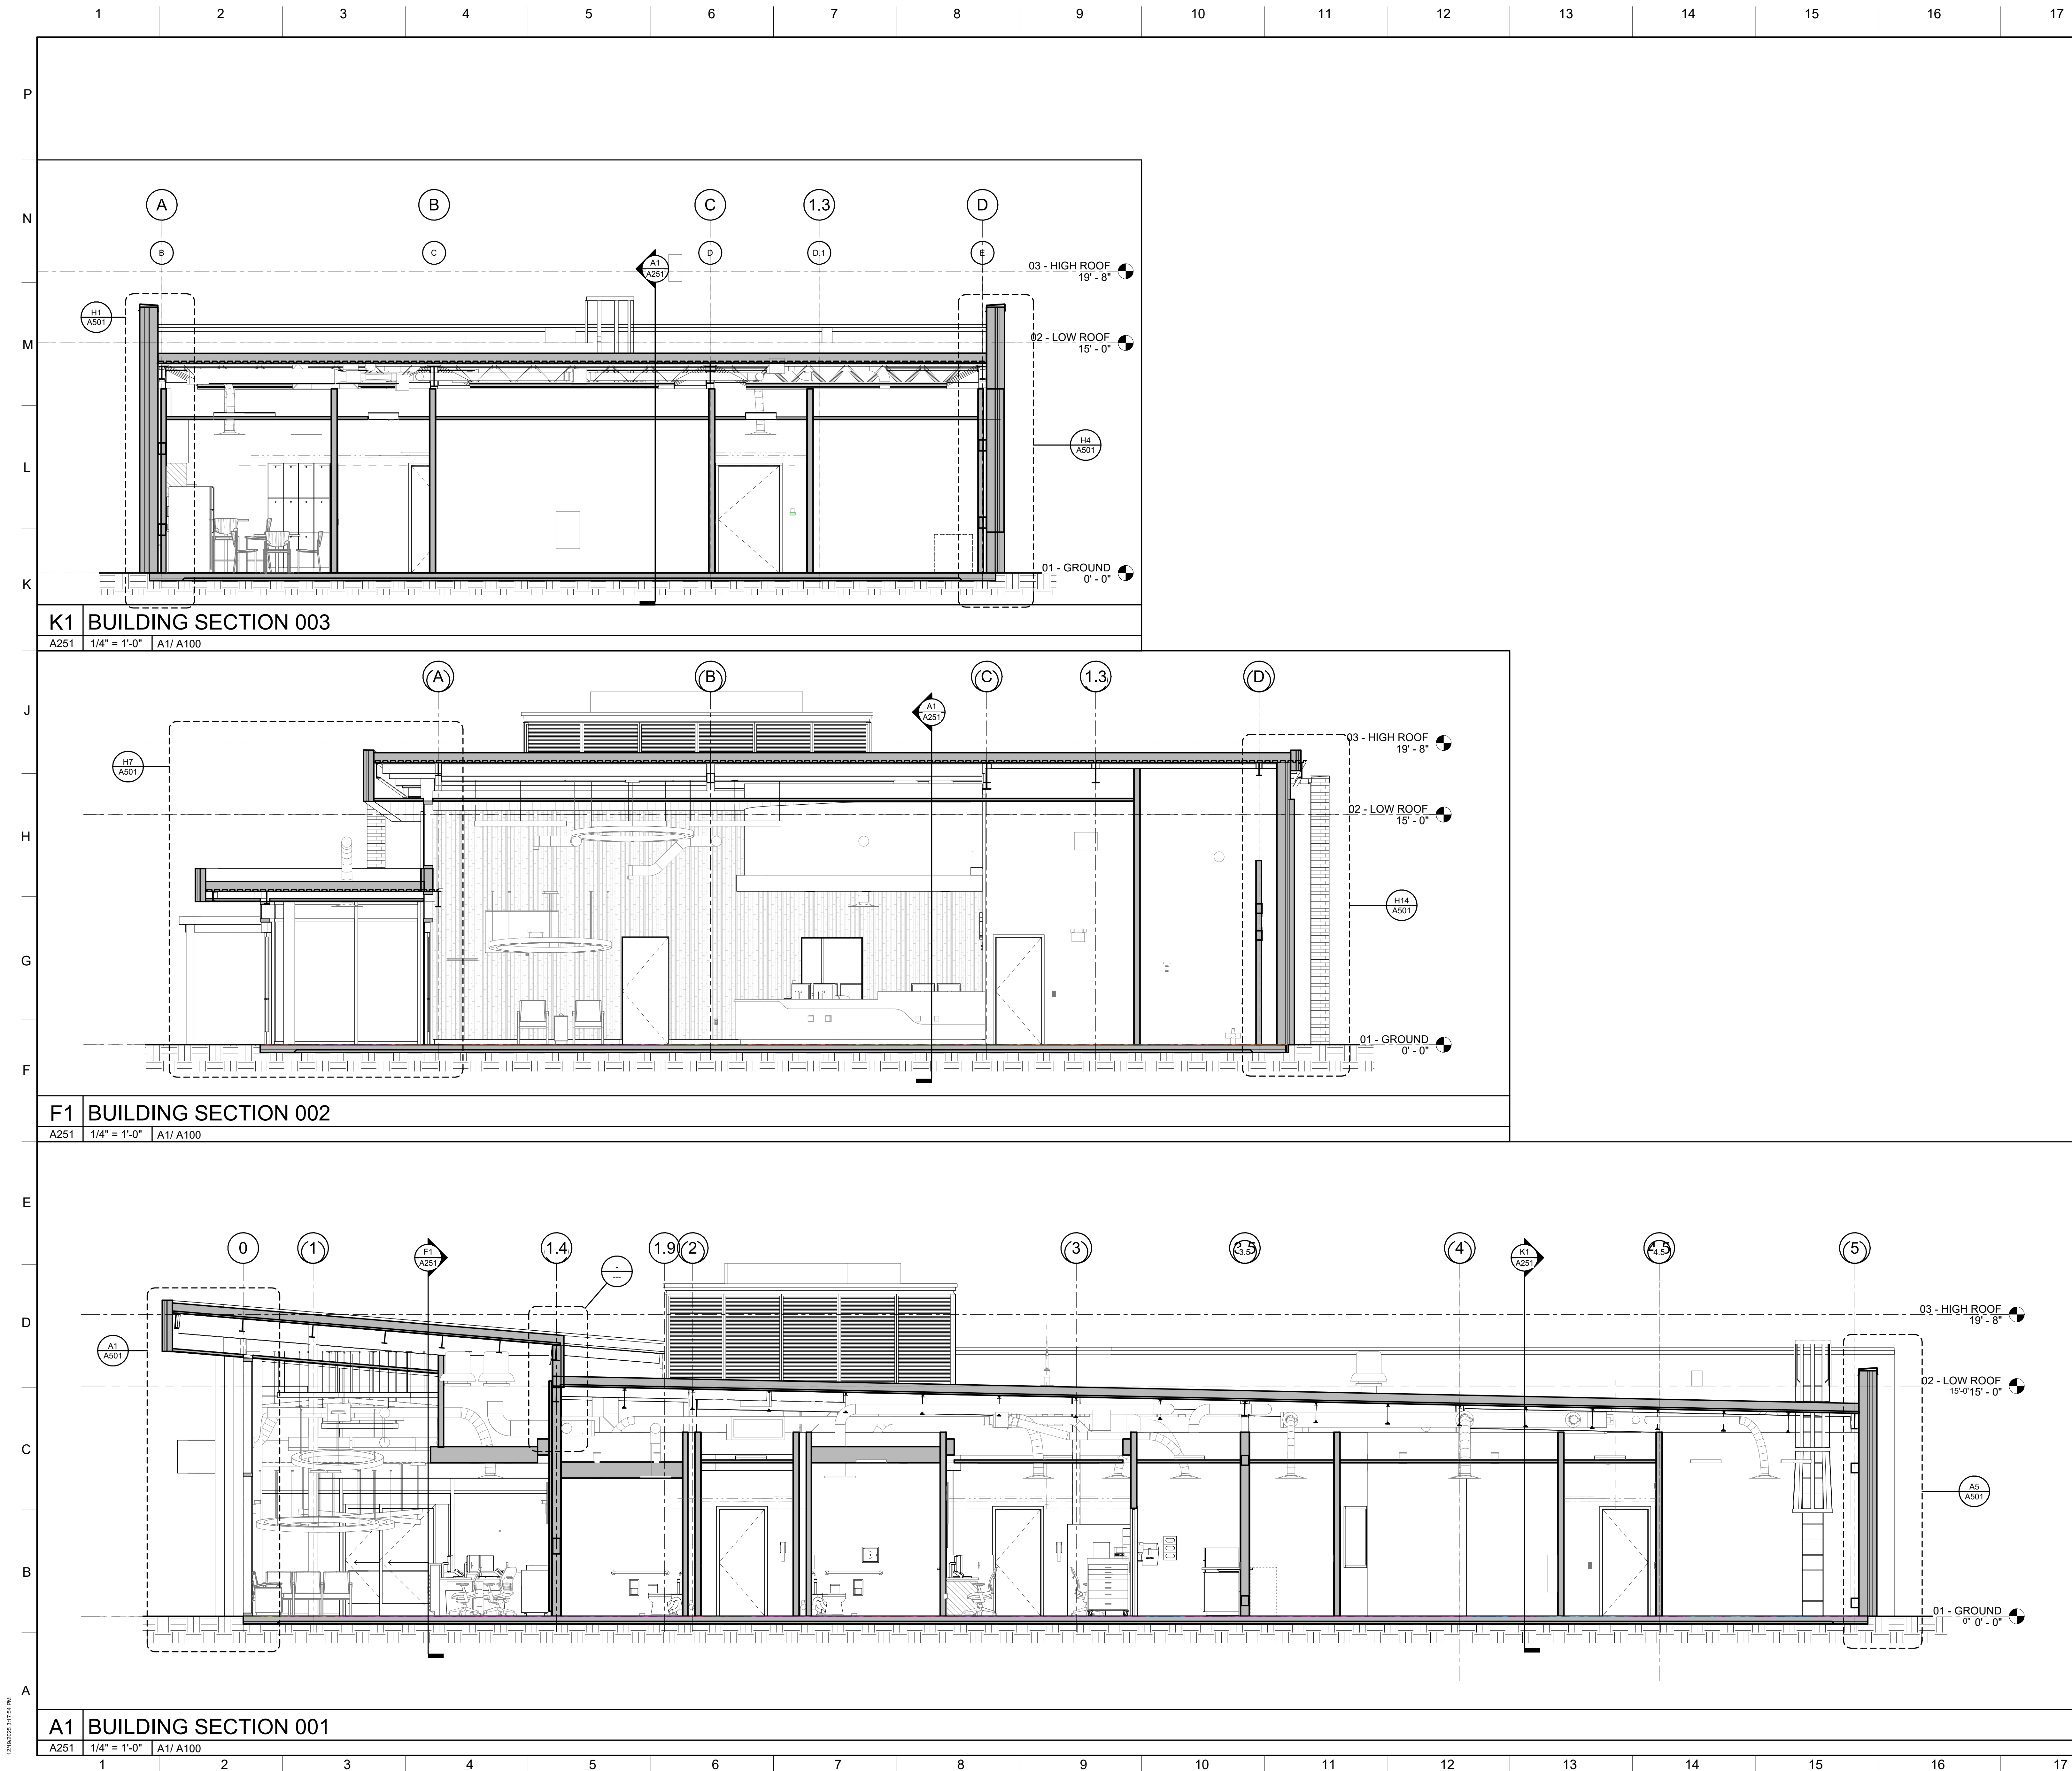



A1 LEVEL 100 REFLECTED CEILING PLAN

A400 3/16" = 1'-0" 1/ A031

CEILING TYPE NOTES

CEILING TYPE	
X	X'-X"
CEILING HEIGHT	
A1	ARMSTRONG CANYON SQ 1490 SIZE: 24x24 GRID: PRELUDE XL COLOR: WHITE
A2	ARMSTRONG ULTIMA SQ 1910 SIZE: 24x24 GRID: PRELUDE XL COLOR: WHITE
G1	GYPSUM BOARD CEILING TYPE 1 - SEE A700 FOR PAINT
W1	RULON ENDURE LINEAR 9X0 EL900 WITH INTEGRATED SPACER, SQUARE EDGE

REFLECTED CEILING PLAN LEGEND

	EXISTING CEILING TO REMAIN
	2 x 2 ACOUSTICAL LAY IN CEILING SYSTEM
	PAINTED GYPSUM BOARD CEILING
	LINEAR WOOD PLANK CEILING
	HATCH INDICATES LOCATION OF PARTIAL CEILING TILES
	SOFFIT ABOVE WALL CABINET
	CEILING ACCESS PANEL
	CONTROL JOINT
	SCONCE
	PENDANT MOUNTED FIXTURE
	RECESSED DOWNLIGHT
	2' x 4' LAY-IN LIGHT FIXTURE
	2' x 2' LAY-IN LIGHT FIXTURE
	STRIP FIXTURE
	CEILING FAN
	FIRE ALARM SPEAKER
	EXIT SIGN
	EXIT SIGN- WALL MOUNTED
	EXIT SIGN/ EMERGENCY LIGHT WALL MOUNTED
	WALL MOUNTED EMERGENCY LIGHT
	HVAC RETURN OR EXHAUST FAN
	HVAC SUPPLY AIR DIFFUSER
	LINEAR AIR DIFFUSER

GENERAL NOTES

- A. REFLECTED CEILING PLANS MAY NOT SHOW FULL EXTENT OF LIGHTING, MECHANICAL PENETRATIONS OR REQUIRED ACCESS PANELS. REFER TO ENGINEERING DISCIPLINE DRAWINGS FOR ADDITIONAL INFORMATION.
- B. ALL LIGHT FIXTURES, DIFFUSER, SPRINKLER HEADS, ETC. IN ACOUSTICAL LAY-IN CEILING S SHALL BE LOCATED IN THE CENTER OF THE CEILING, UNLESS NOTED OTHERWISE.
- C. ALL SPRINKLER HEADS IN GYP. BD. CEILING SHALL BE CONCEALED SPRINKLER HEADS. SPRINKLER HEAD COVERS TO MATCH COLOR OF ADJACENT SURFACE.
- D. REFER TO E001 FOR LIGHT FIXTURE TYPES.
- E. ALL MECH. AND PLUMBING PIPING AND EQUIPMENT TO BE INSTALLED WITHIN THE BAR JOIST WHERE POSSIBLE.
- F. ALL GYP. SOFFIT OVER MILLWORK TO MATCH WALL IN WHICH IT OCCURS.

KEY PLAN




SHEET TITLE
REFLECTED
CEILING PLAN

SHEET NUMBER

A400

12/18/2025 3:17:59 PM

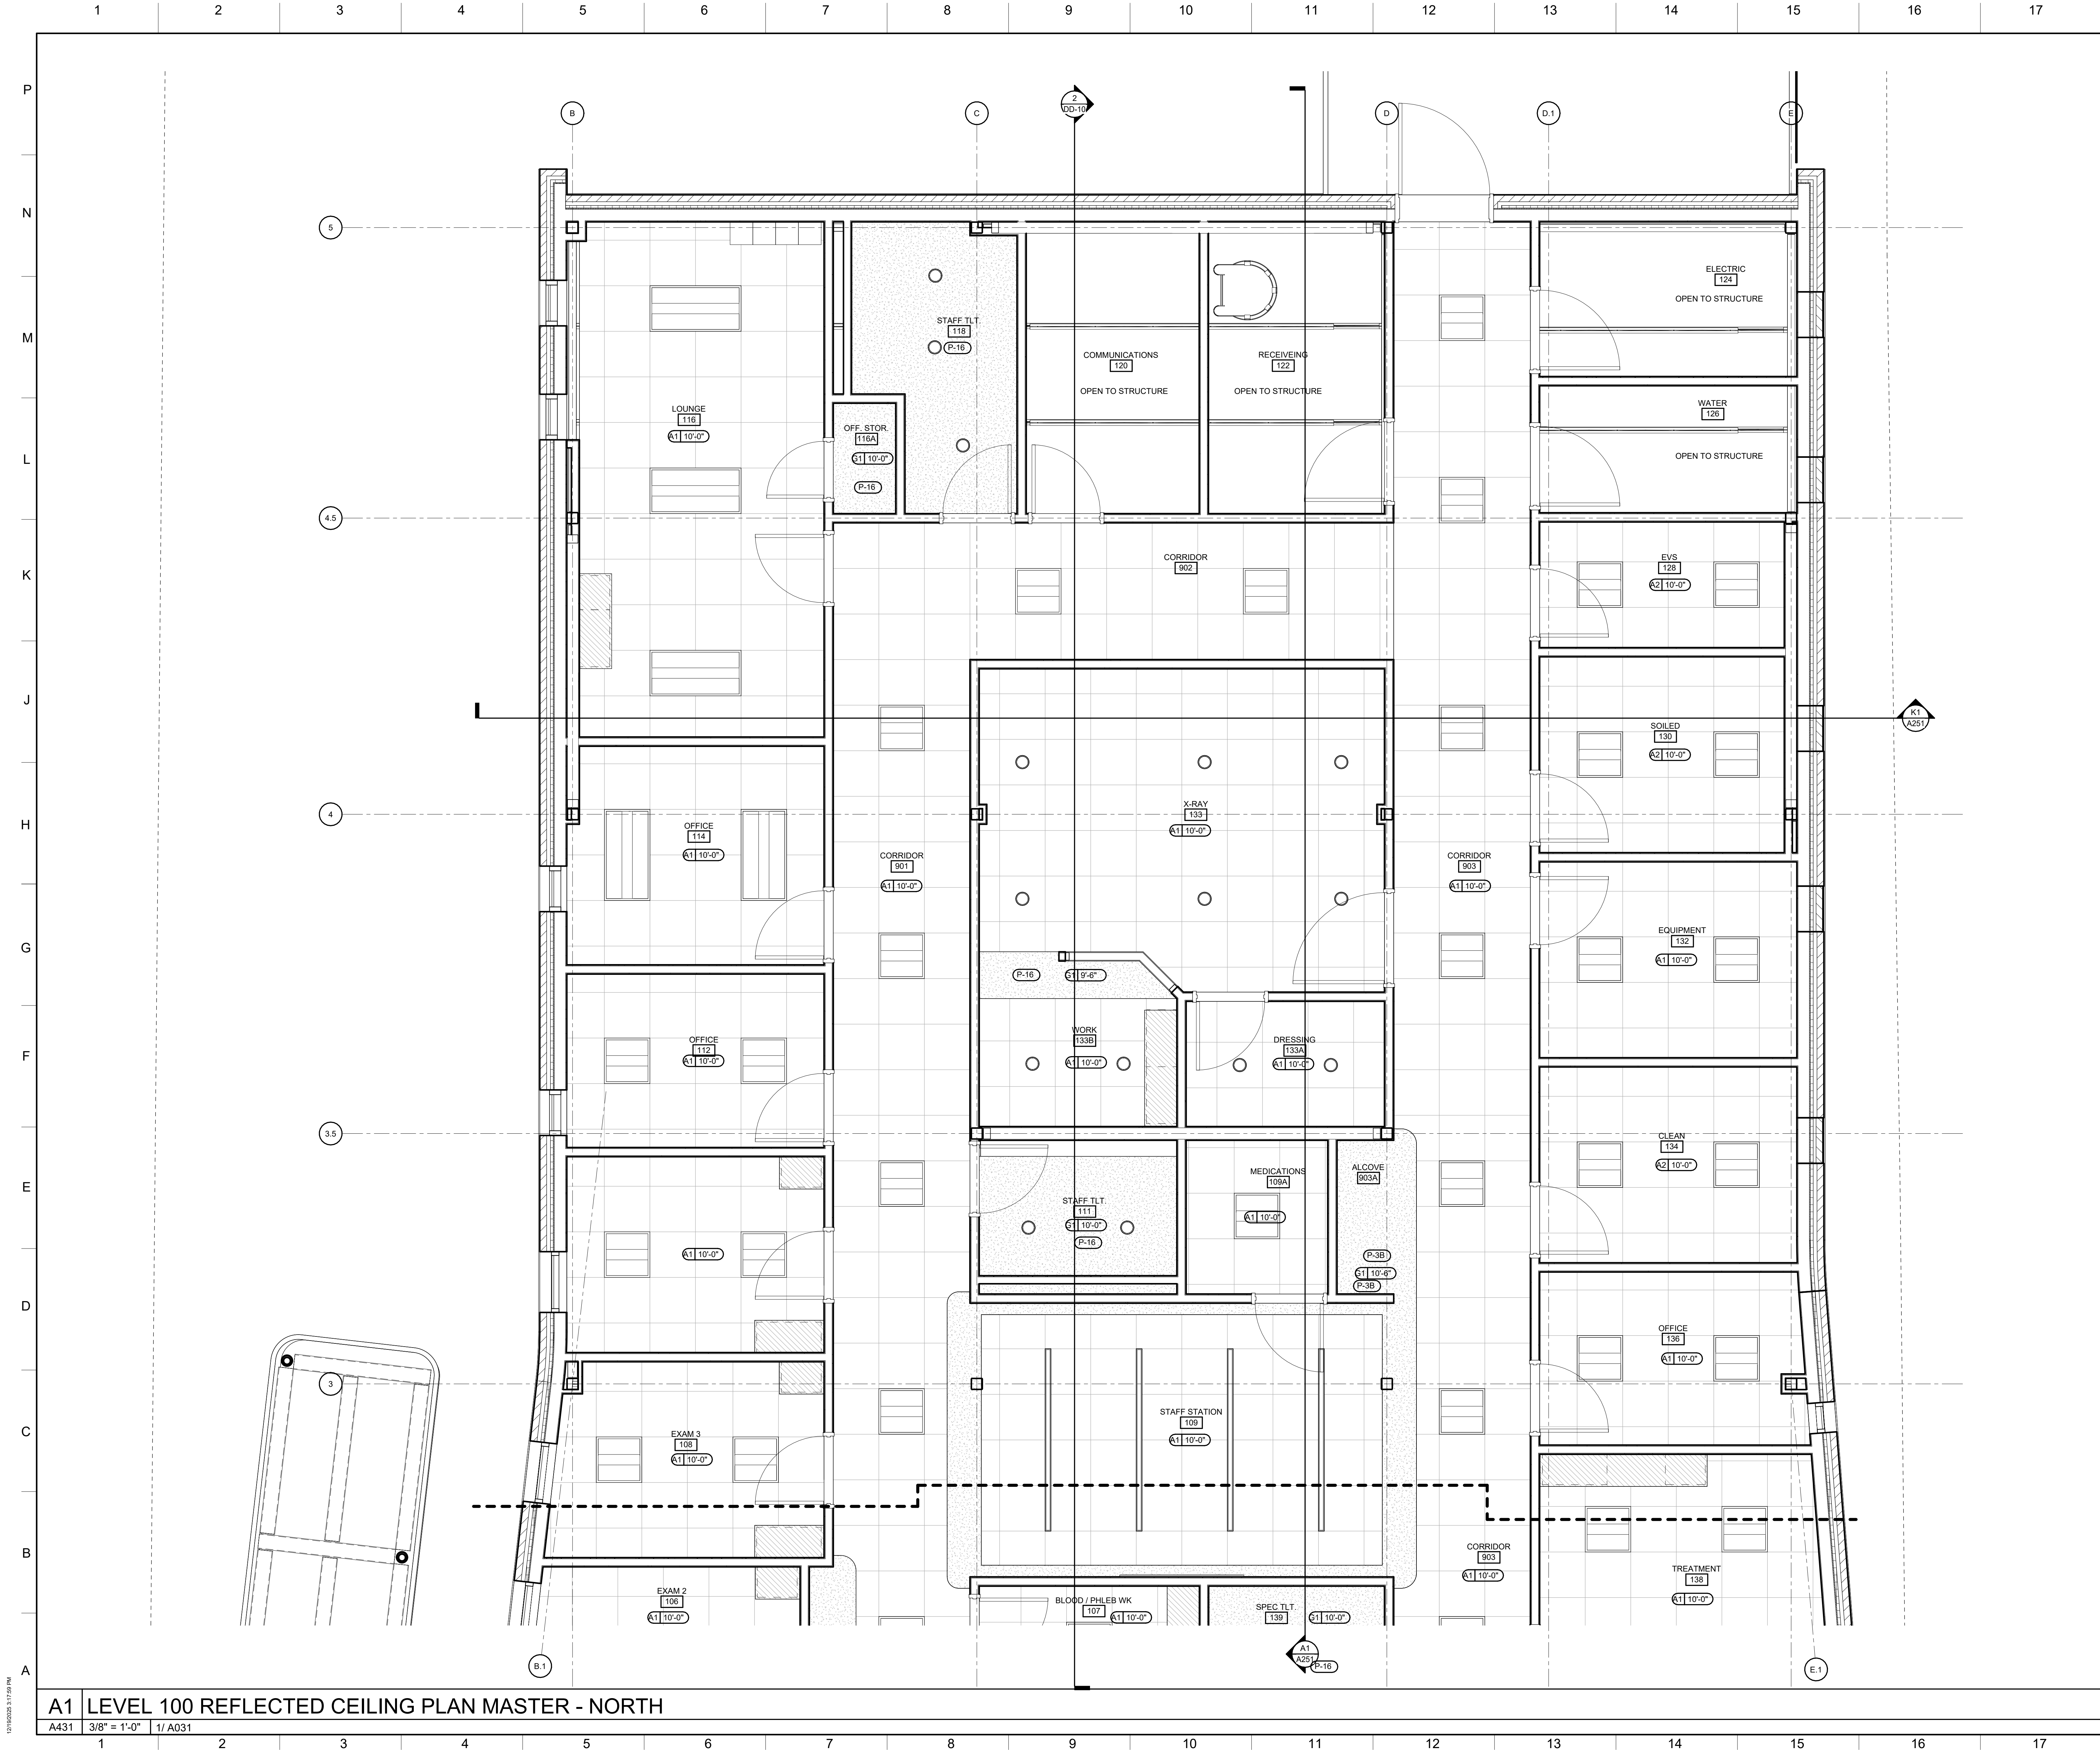

CEILING TYPE NOTES	
CEILING TYPE	CEILING HEIGHT
A1	ARMSTRONG CANYON SQ 1490 SIZE: 24x24 GRID: PRELUDE XL COLOR: WHITE
A2	ARMSTRONG ULTIMA SQ 1910 SIZE: 24x24 GRID: PRELUDE XL COLOR: WHITE
G1	GYPSUM BOARD CEILING TYPE 1 - SEE A700 FOR PAINT
W1	RULON ENDURE LINEAR 9X0 EL900 WITH INTEGRATED SPACER, SQUARE EDGE

REFLECTED CEILING PLAN LEGEND	
	EXISTING CEILING TO REMAIN
	2 x 2 ACOUSTICAL LAY IN CEILING SYSTEM
	PAINTED GYPSUM BOARD CEILING
	LINEAR WOOD PLANK CEILING
	HATCH INDICATES LOCATION OF PARTIAL CEILING TILES
	SOFFIT ABOVE WALL CABINET
	CEILING ACCESS PANEL
	C.J. CONTROL JOINT
	SCONCE
	PENDANT MOUNTED FIXTURE
	RECESSED DOWNLIGHT
	2' x 4' LAY-IN LIGHT FIXTURE
	2' x 2' LAY-IN LIGHT FIXTURE
	STRIP FIXTURE
	CEILING FAN
	FIRE ALARM SPEAKER
	EXIT SIGN
	EXIT SIGN- WALL MOUNTED
	EXIT SIGN- EMERGENCY LIGHT WALL MOUNTED
	WALL MOUNTED EMERGENCY LIGHT
	HVAC RETURN OR EXHAUST FAN
	HVAC SUPPLY AIR DIFFUSER
	LINEAR AIR DIFFUSER

CDH

ARCHITECTURE

3330 Cumberland Blvd. SE
Suite 100
Atlanta, GA 30339
770.423.0016
www.cdhparkers.com

COPYRIGHT © 2025 by CDH PARTNERS INC.
All rights reserved.

GRADY HEALTH SYSTEM

GRADY ESTORIA URGENT CARE

Corner of Memorial Drive & Estoria Street
Atlanta GA 30316

PROJECT NO: 25132.00

DD PACKAGE 12/18/25


NOT ISSUED FOR CONSTRUCTION

SHEET TITLE

ENLARGED CEILING PLAN

SHEET NUMBER

A431

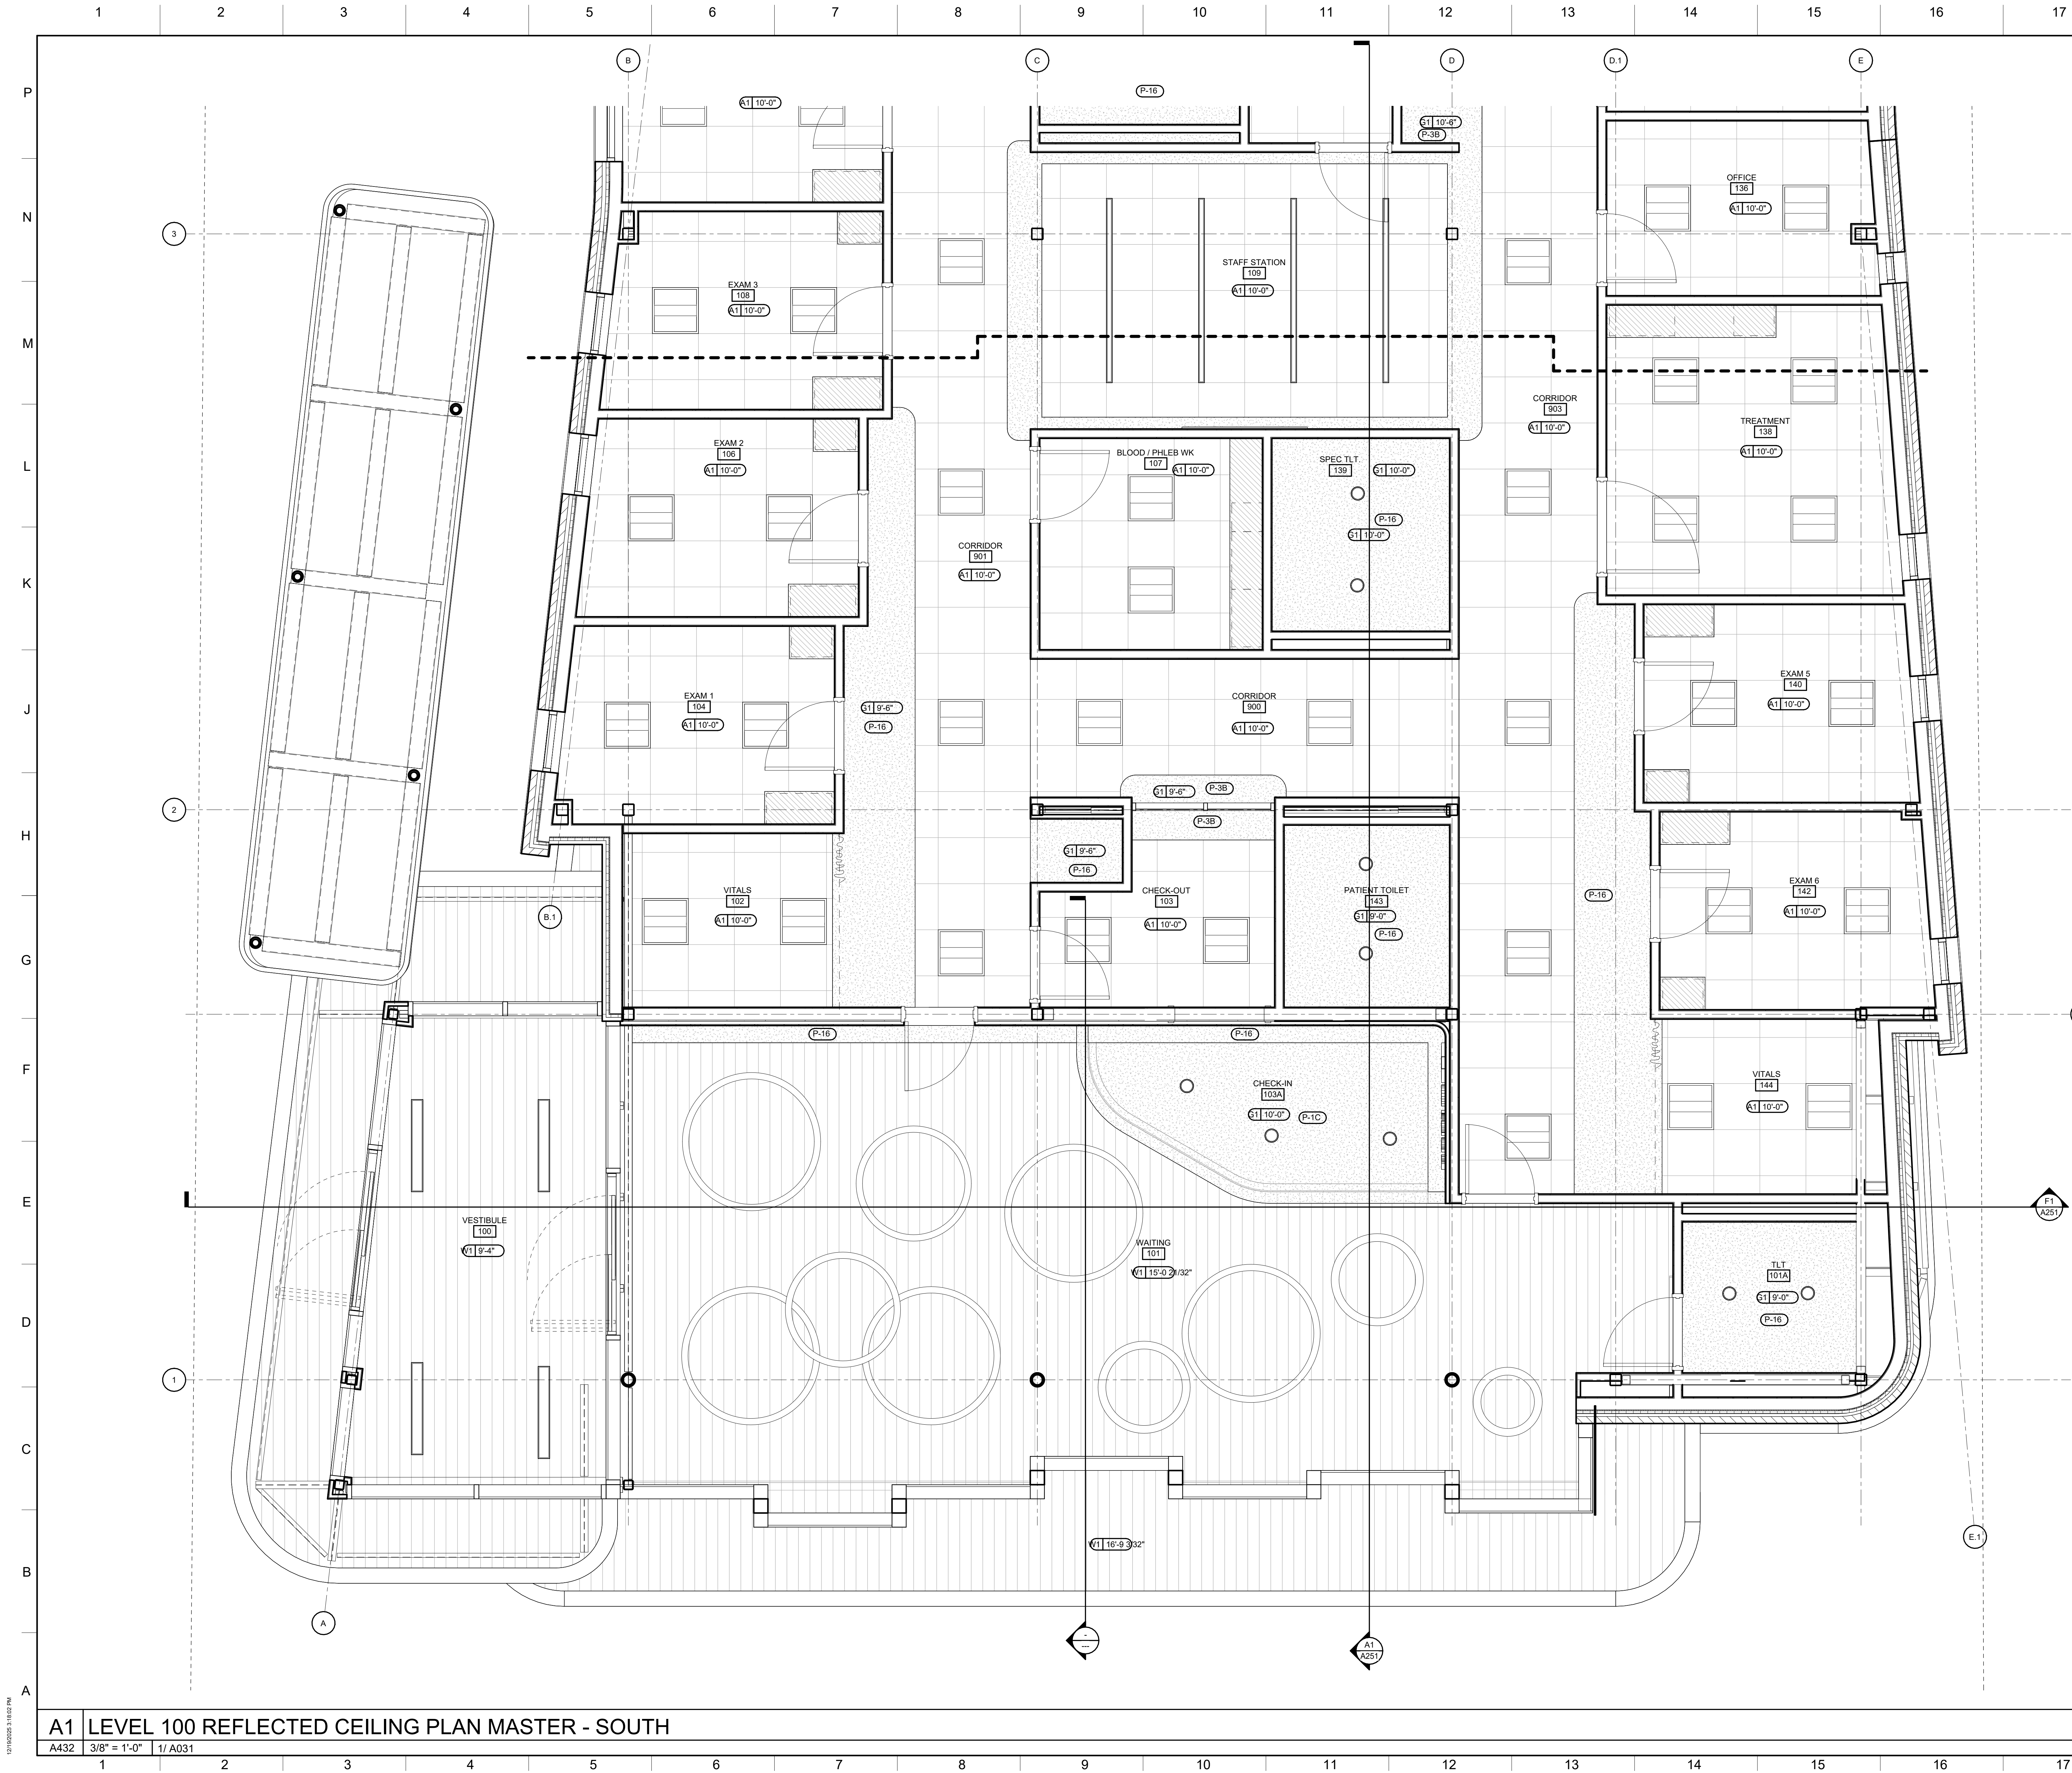

CEILING TYPE NOTES	
CEILING TYPE	CEILING HEIGHT
A1	ARMSTRONG CANYON SQ 1490 SIZE: 24x24 GRID: PRELUDE XL COLOR: WHITE
A2	ARMSTRONG ULTIMA SQ 1910 SIZE: 24x24 GRID: PRELUDE XL COLOR: WHITE
G1	GYPSUM BOARD CEILING TYPE 1 - SEE A700 FOR PAINT
W1	RULON ENDURE LINEAR 9X0 EL900 WITH INTEGRATED SPACER, SQUARE EDGE

REFLECTED CEILING PLAN LEGEND	
	EXISTING CEILING TO REMAIN
	2 x 2 ACOUSTICAL LAY IN CEILING SYSTEM
	PAINTED GYPSUM BOARD CEILING
	LINEAR WOOD PLANK CEILING
	HATCH INDICATES LOCATION OF PARTIAL CEILING TILES
	SOFFIT ABOVE WALL CABINET
	CEILING ACCESS PANEL
	CONTROL JOINT
	SCONCE
	PENDANT MOUNTED FIXTURE
	RECESSED DOWNLIGHT
	2' x 4' LAY-IN LIGHT FIXTURE
	2' x 2' LAY-IN LIGHT FIXTURE
	STRIP FIXTURE
	CEILING FAN
	FIRE ALARM SPEAKER
	EXIT SIGN
	EXIT SIGN - WALL MOUNTED
	EXIT SIGN/ EMERGENCY LIGHT WALL MOUNTED
	WALL MOUNTED EMERGENCY LIGHT
	HVAC RETURN OR EXHAUST FAN
	HVAC SUPPLY AIR DIFFUSER
	LINEAR AIR DIFFUSER

CDH

ARCHITECTURE

3330 Cumberland Blvd. SE
Suite 100
Atlanta, GA 30339
770.423.0016
www.cdpartners.com

GRADY HEALTH SYSTEM

GRADY ESTORIA URGENT CARE

Corner of Memorial Drive & Estoria Street
Atlanta GA 30316

PROJECT NO: 25132.00

DD PACKAGE 12/18/25

NOT ISSUED FOR CONSTRUCTION

SHEET TITLE


ENLARGED CEILING PLAN

SHEET NUMBER


A432

A1 LEVEL 100 REFLECTED CEILING PLAN MASTER - SOUTH

A432 3/8" = 1'-0" 1/ A031

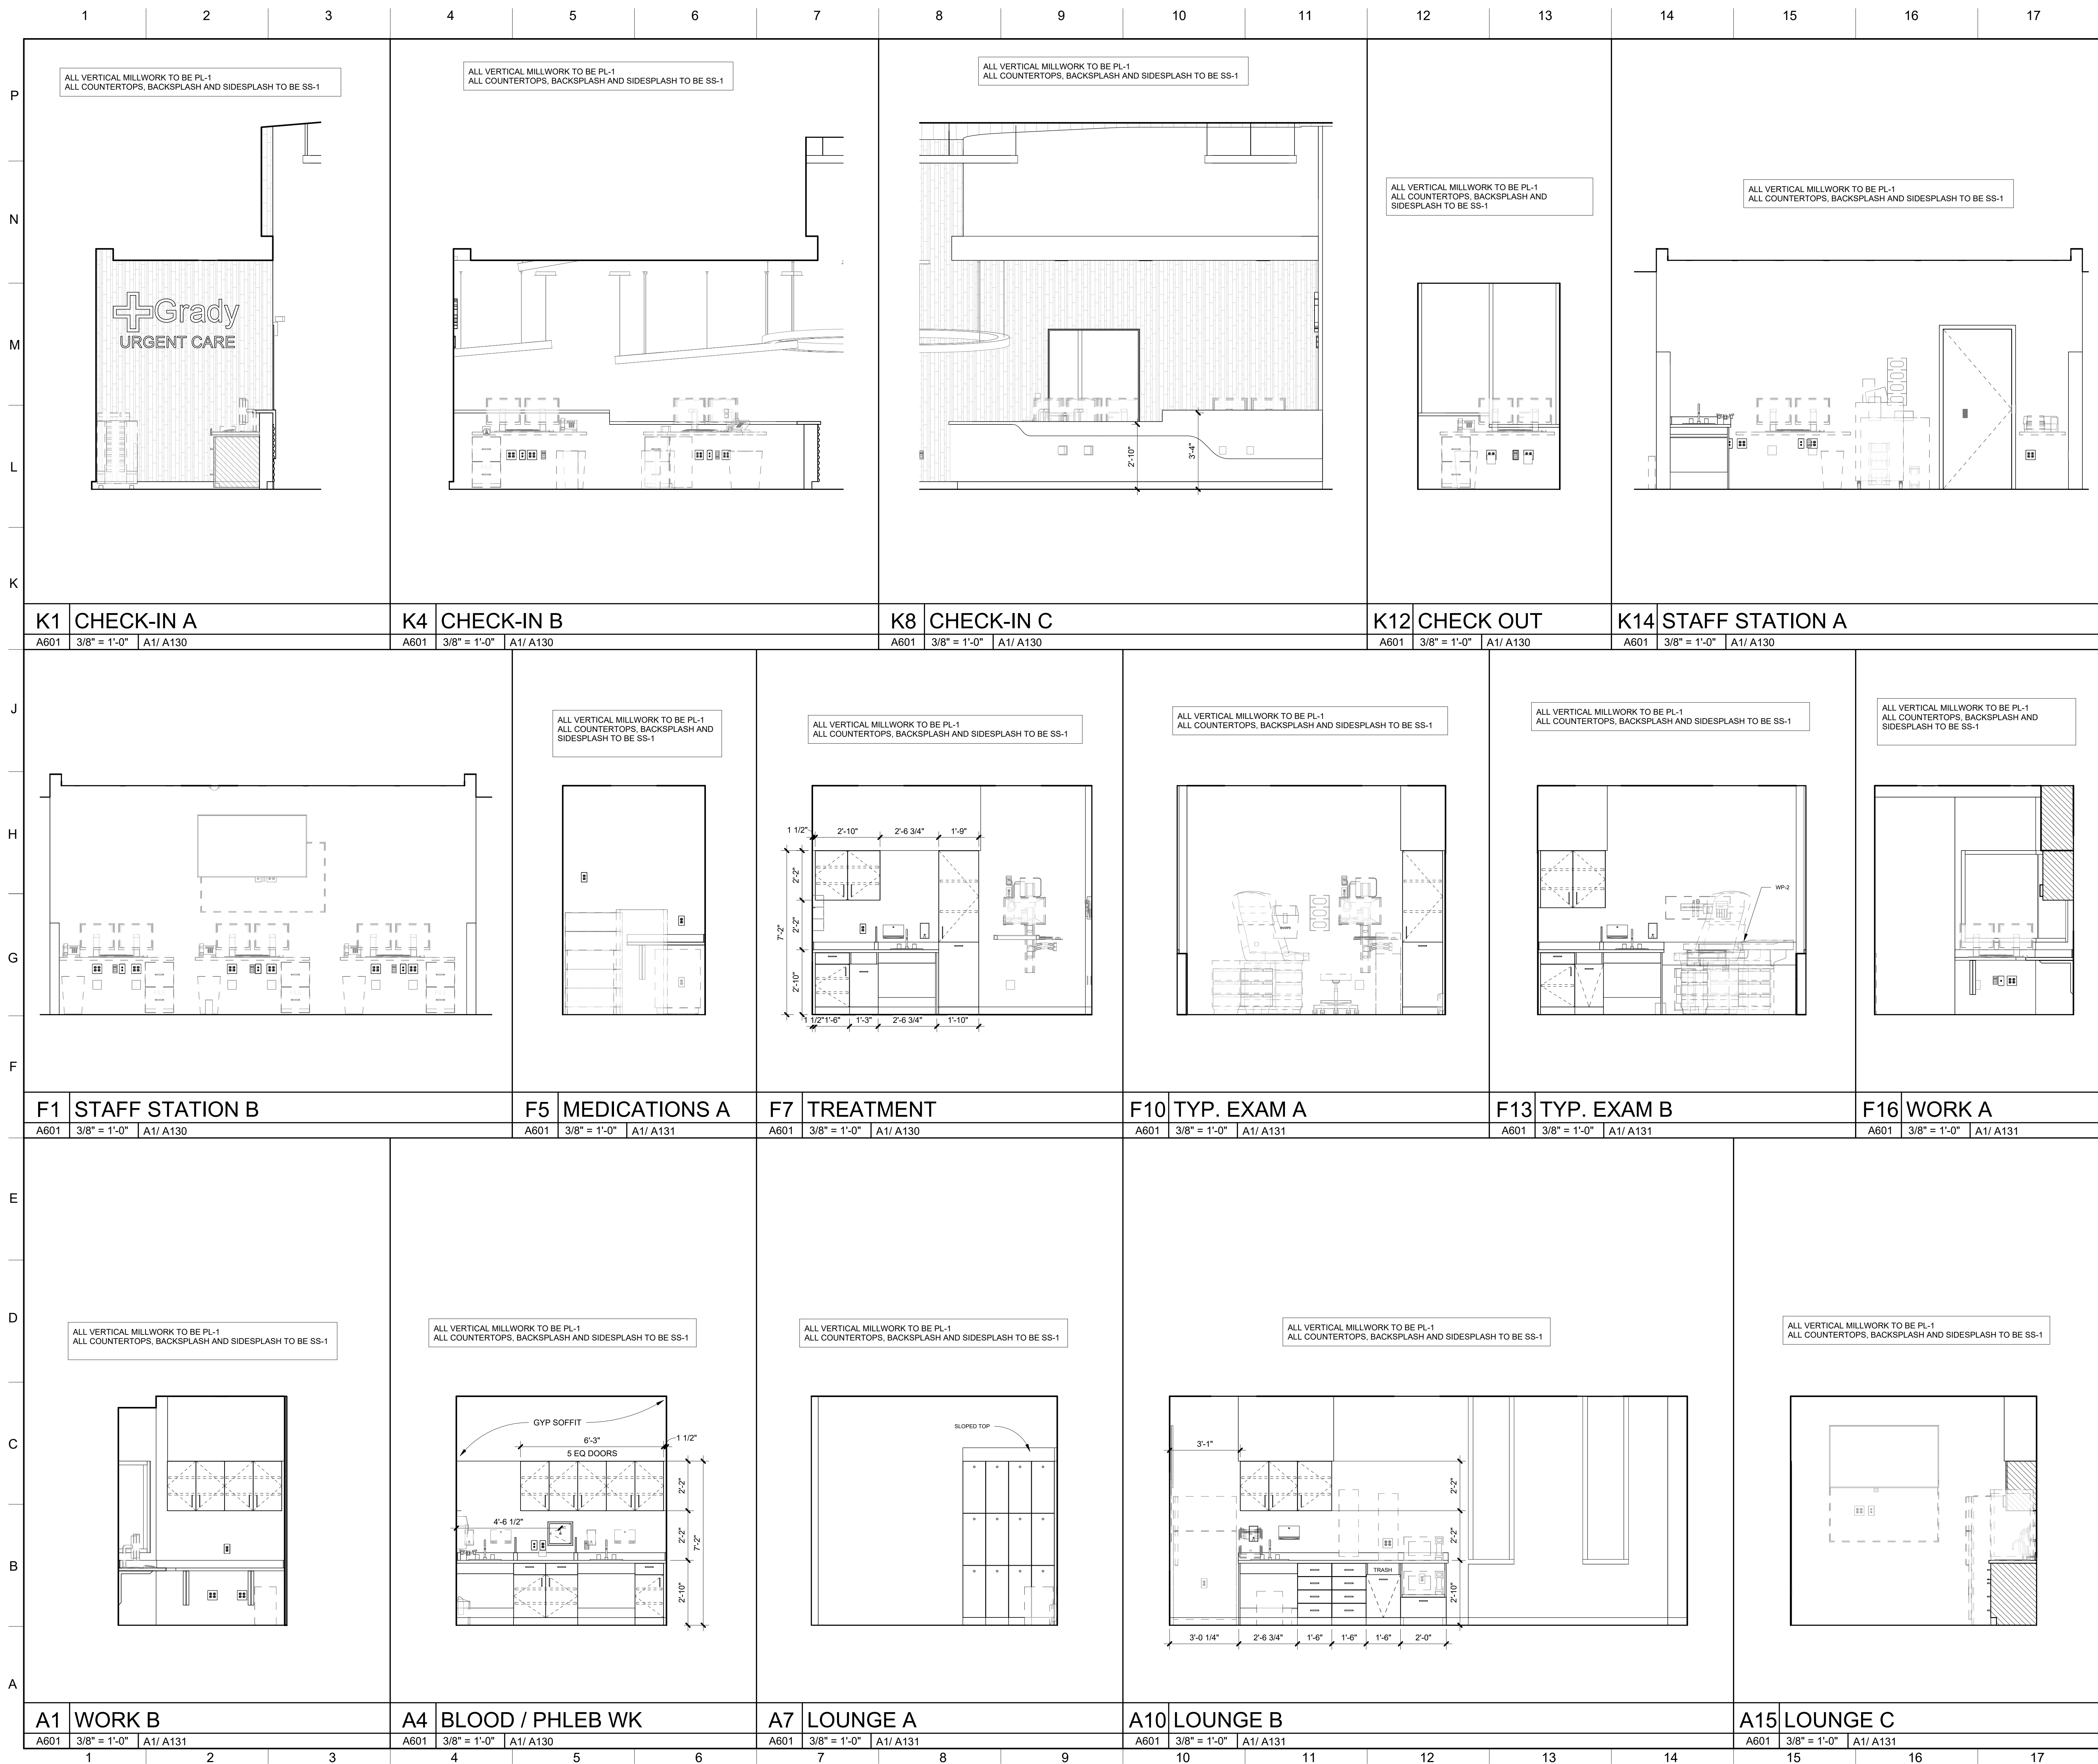

064116	SECTION 064116 - PLASTIC-LAMINATE-FACED ARCHITECTURAL CABINETS
064116.B02	PARTICLEBOARD CORE
064116.B03	SOFTWARE PLYWOOD CORE
064116.E01	CABINET HARDWARE AND ACCESSORIES
066500.A00	SOLID POLYMER FABRICATIONS
066500.A03	UNDERMOUNT SINKS/BOWL

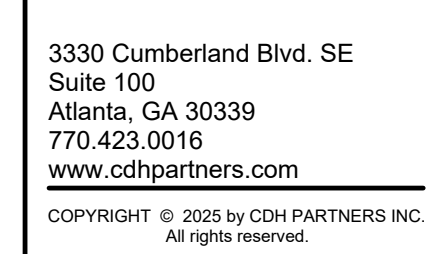

GRADY HEALTH SYSTEM
STORIA UR
Corner of Memorial Drive & Estoria
Atlanta GA 30316

PROJECT NO:		25132.00
DD	DD PACKAGE	12/18/25

NOT ISSUED FOR
CONSTRUCTION

[illegible]

MILLWORK DETAILS & SECTIONS

SHEET NUMBER

A651

